


BLOCK - A

NOTES

1- FOR LIST OF DRAWINGS, LEGEND AND GENERAL NOTES REFER TO DWG. E001

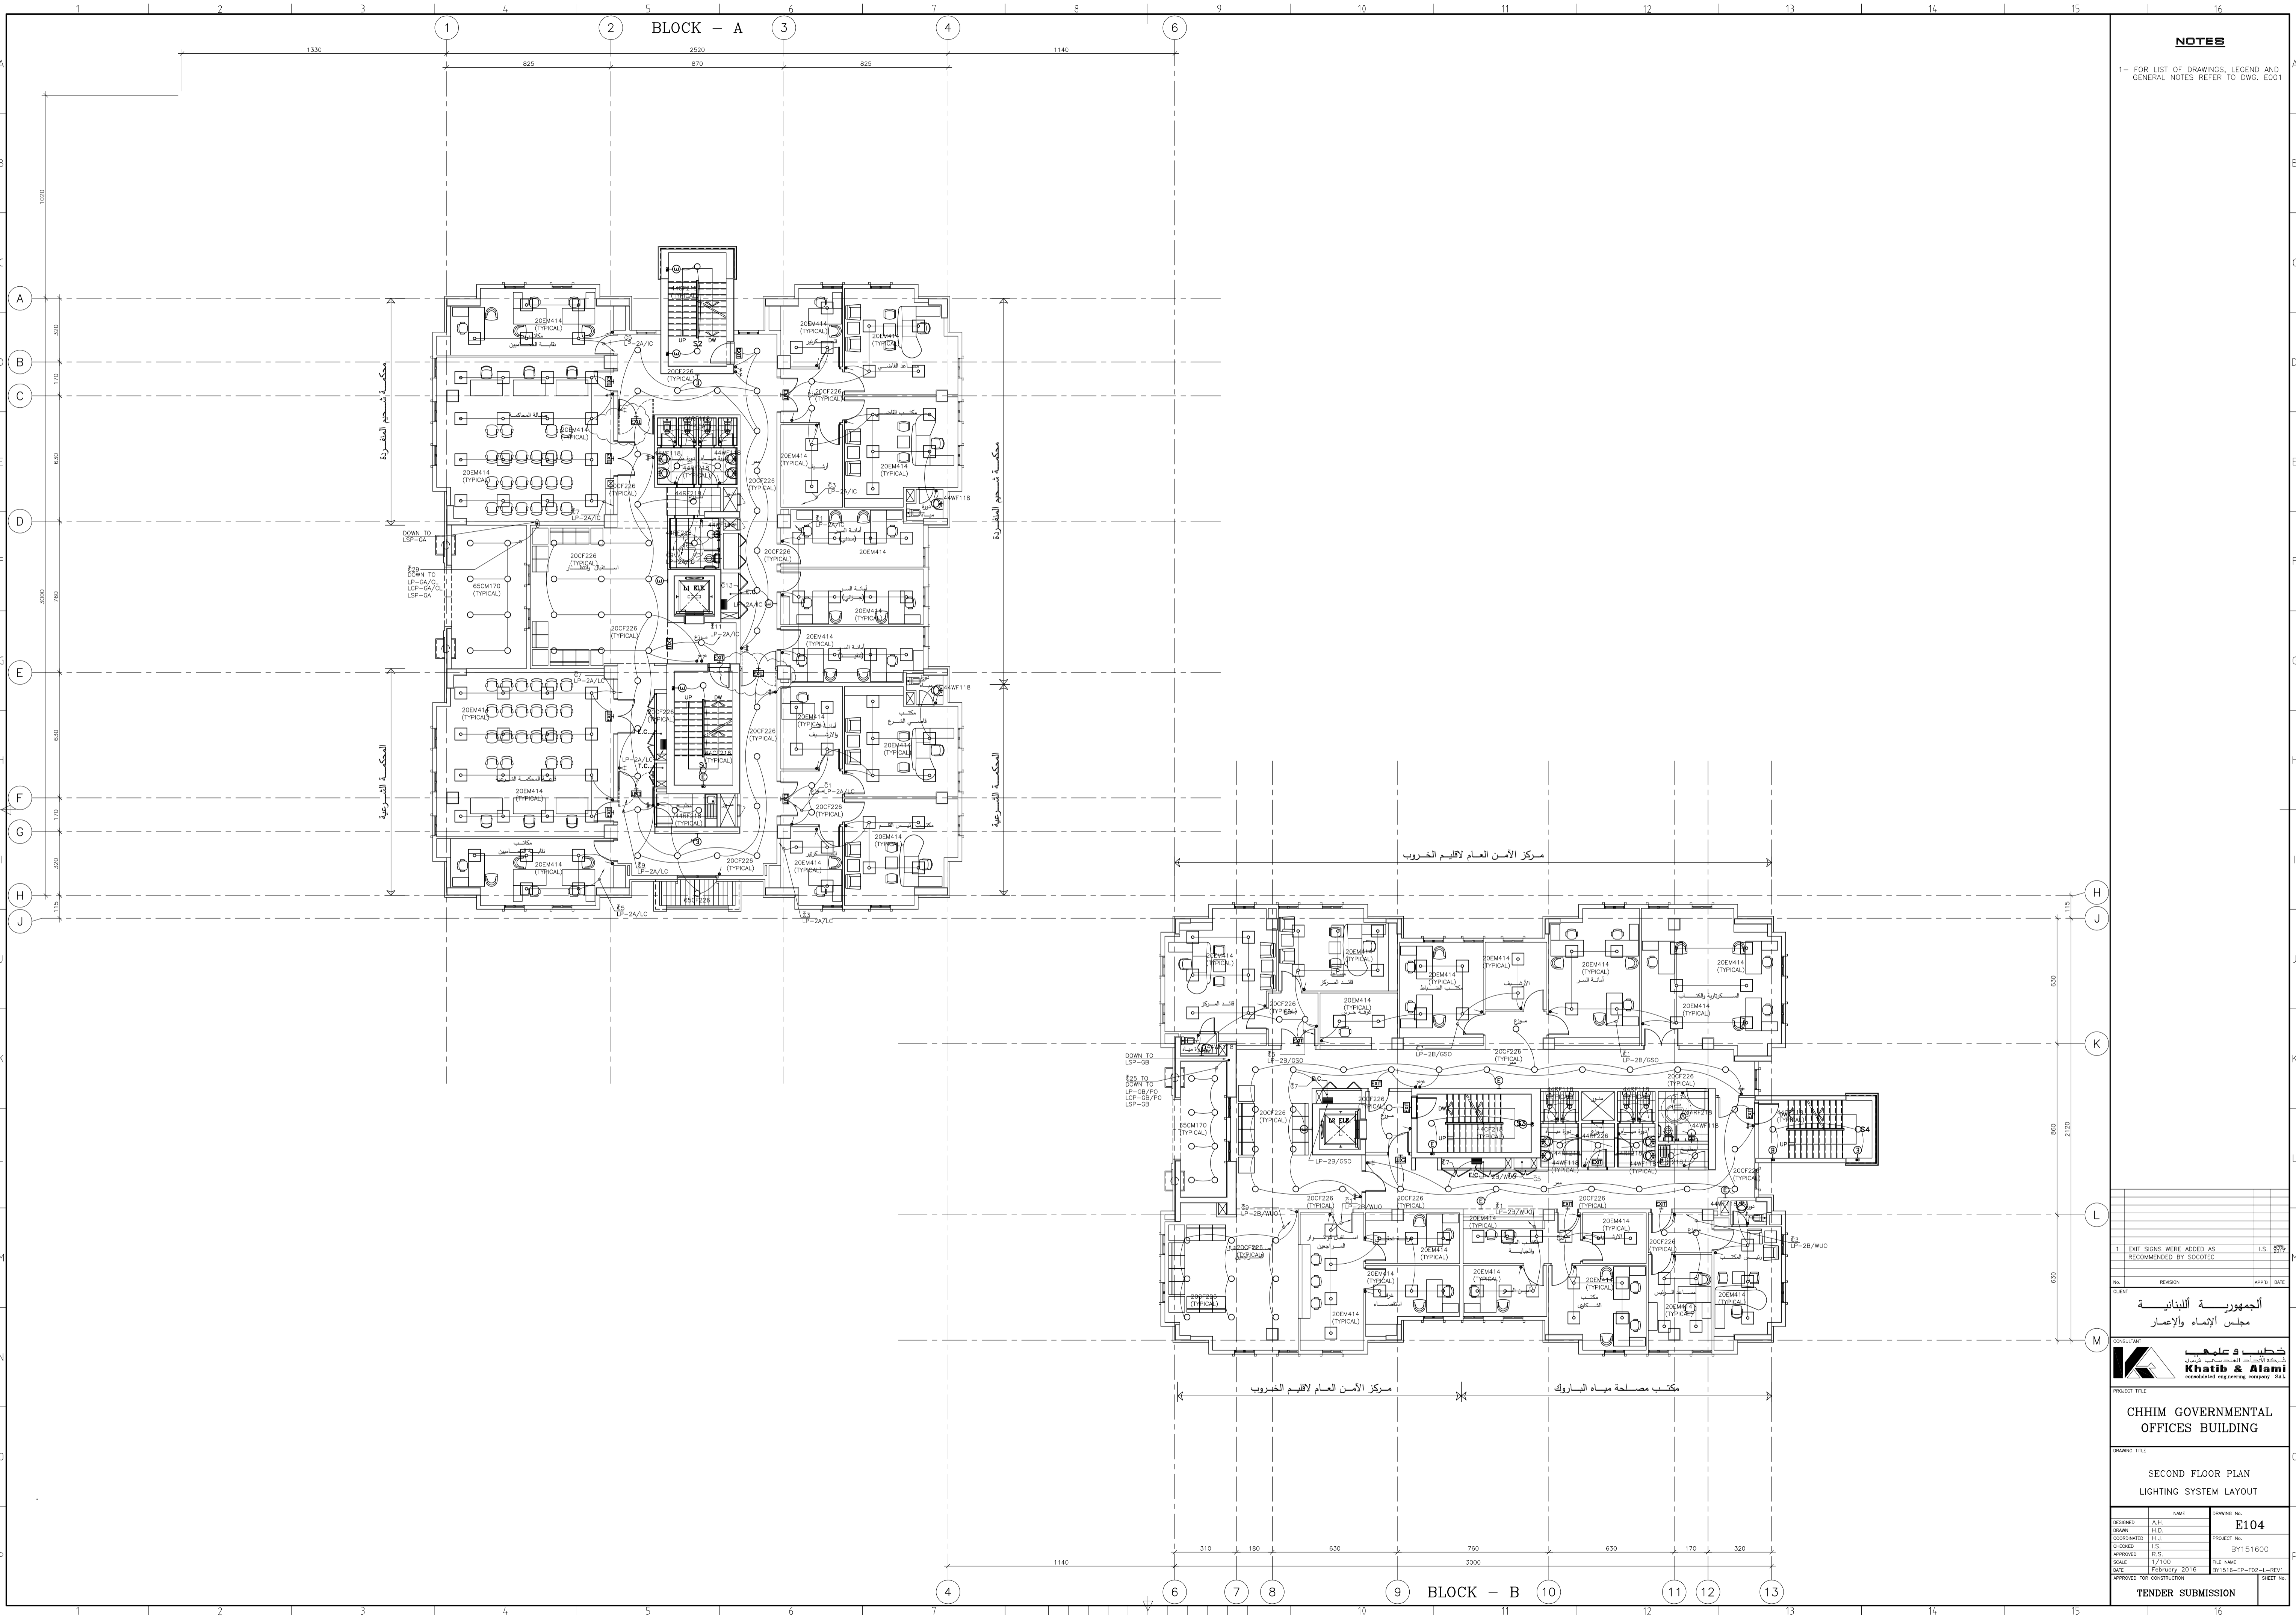

1 EXIT SIGNS WERE ADDED AS RECOMMENDED BY SOCOTEC

الجمهورية اللبنانية
مجلس الإنماء والإعمار



CHHIM GOVERNMENTAL OFFICES BUILDING

SECOND FLOOR PLAN
LIGHTING SYSTEM LAYOUT

DESIGNED	NAME	DRAWING NO.
DESIGNED	A.H.	E104
DRAWN	H.D.	
CORRECTED	H.S.	PROJECT NO. BY151600
CHECKED	R.S.	FILE NAME
APPROVED	R.S.	DATE
SCALE	1/100	BY1516-EP-F02-L-REV1
DATE	February 2016	SHEET NO.
APPROVED FOR CONSTRUCTION		

TENDER SUBMISSION