



NOTES

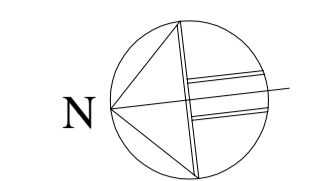

- 1-FOR LEGEND, GENERAL NOTES AND LIST OF MECHANICAL DRAWINGS REFER TO DRAWING No. BY1516-GNL-00.
- 2-FOR RISER DIAGRAM REFER TO DRAWING BY1516-GNL-02.
- 3-FOR MISCELLANEOUS DETAILS, REFER TO DRAWING No. BY1516-GNL-01.

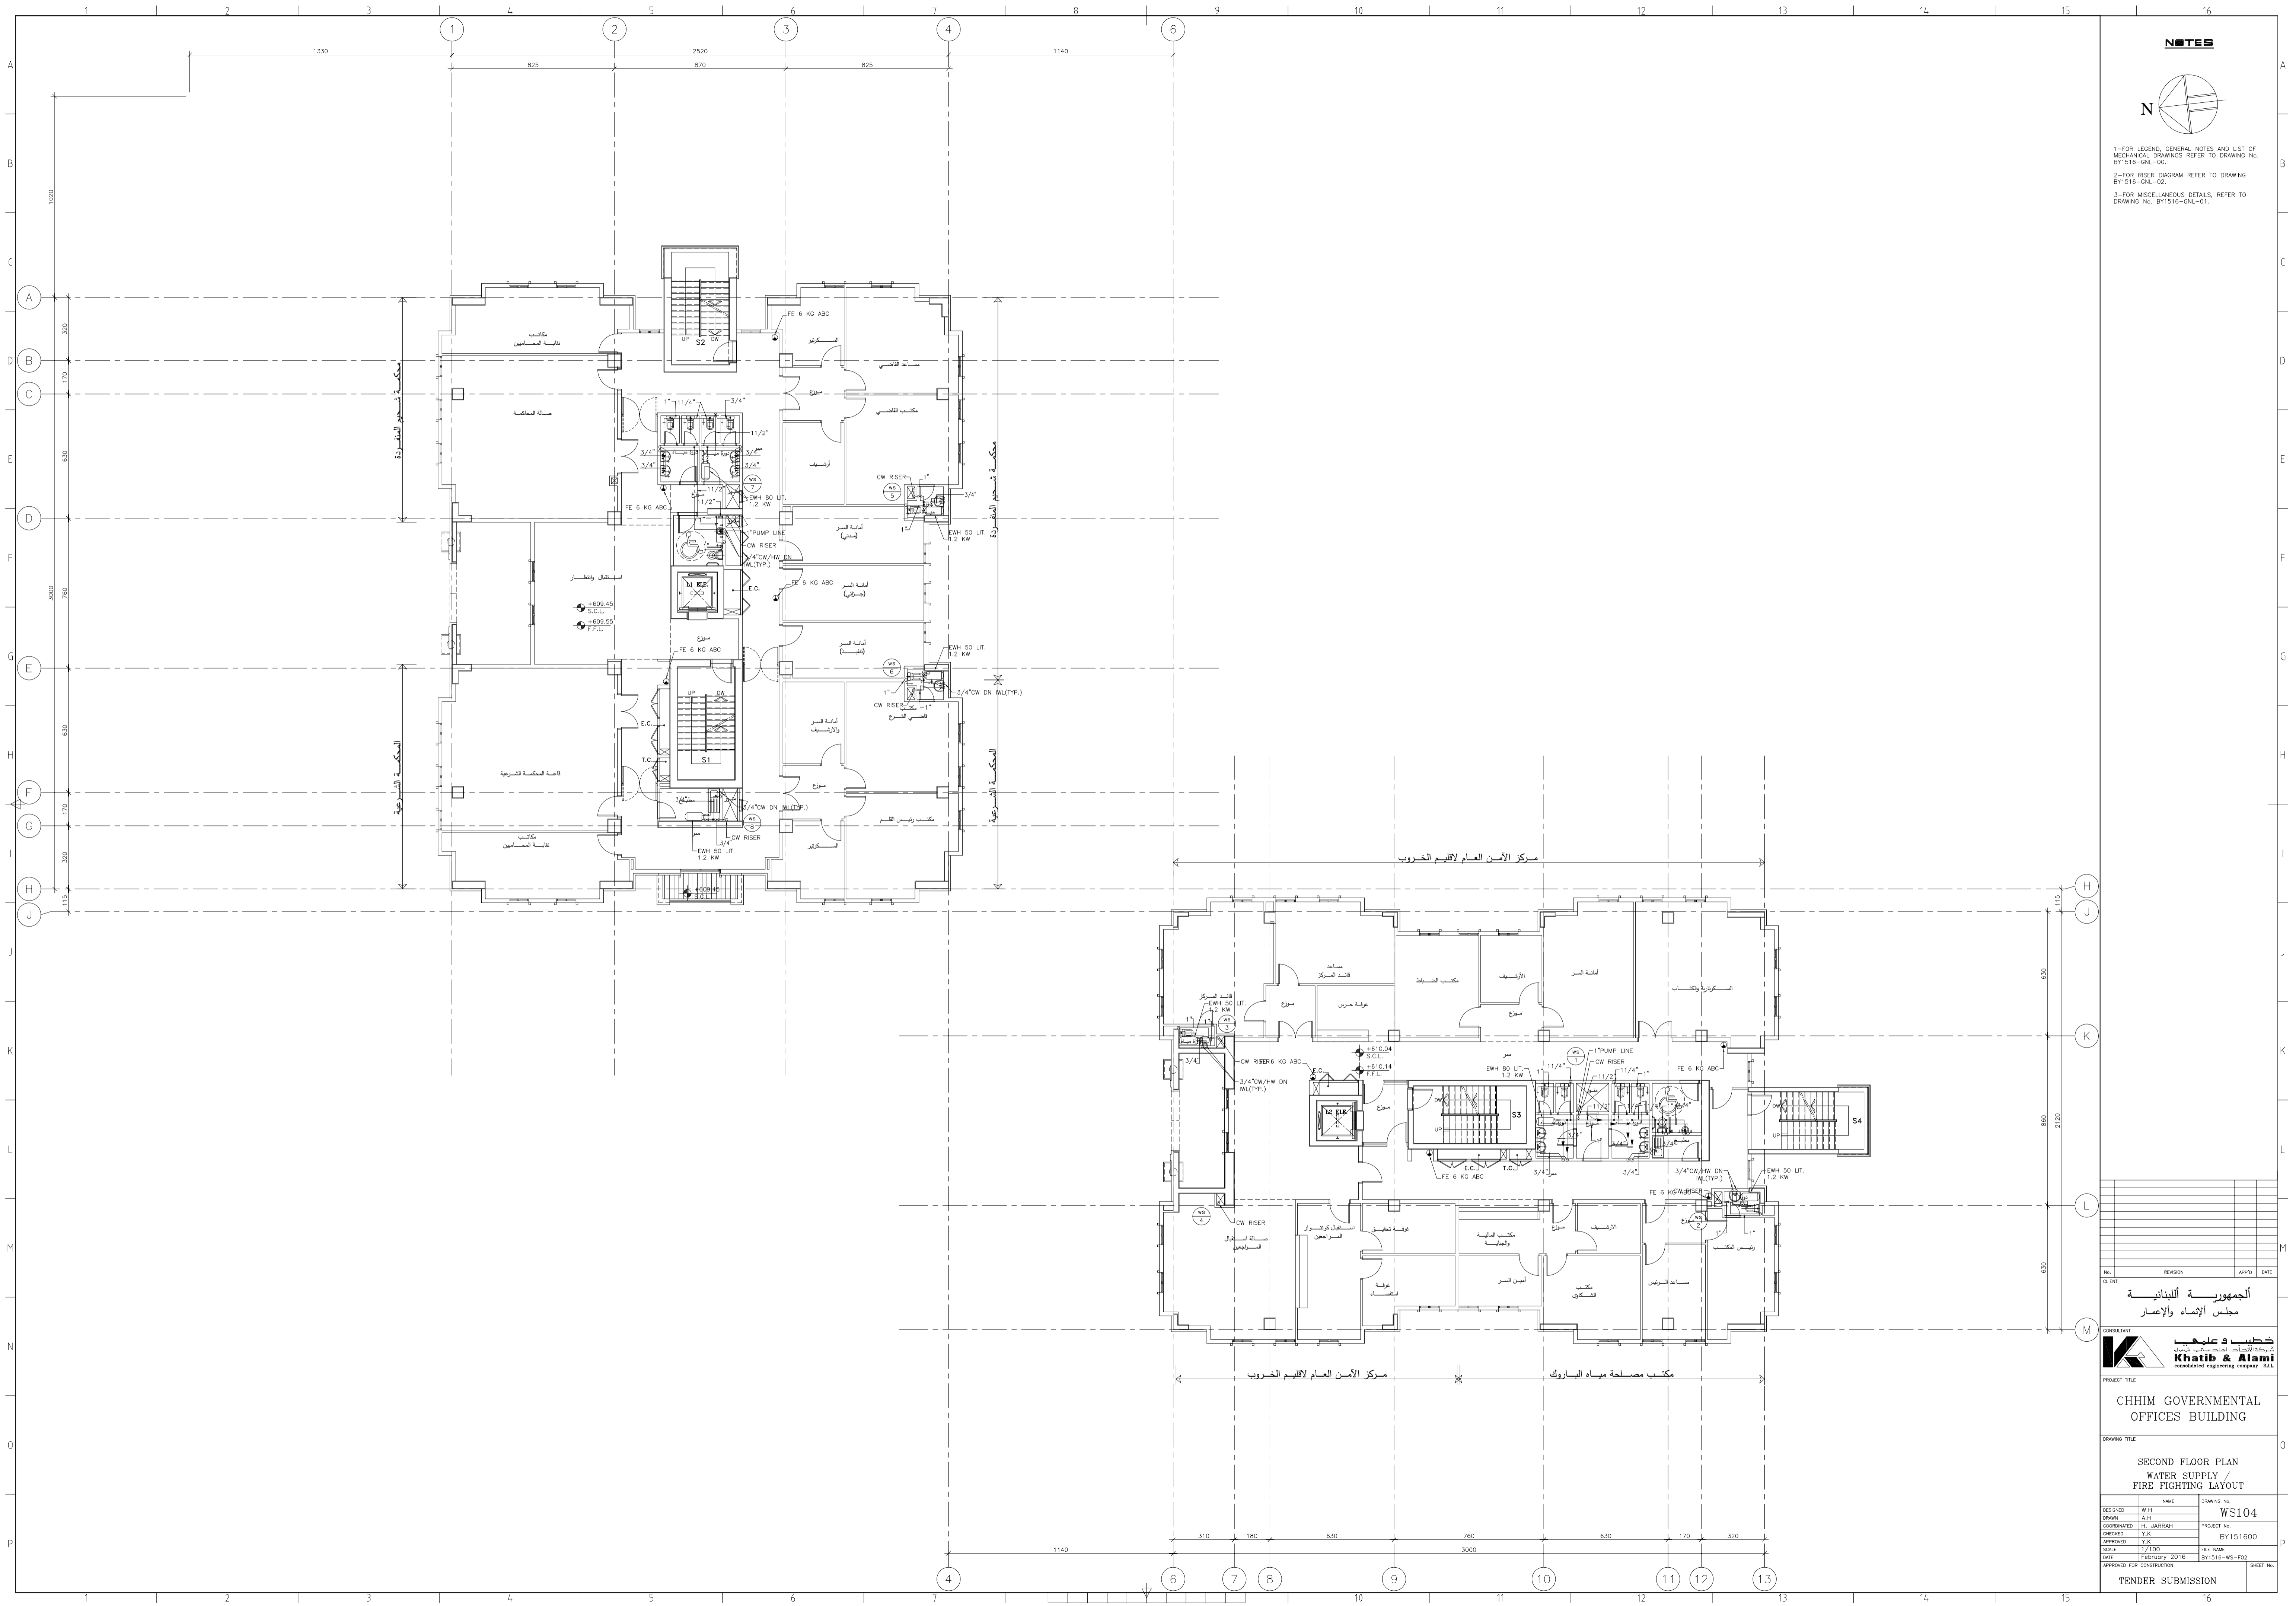

NO. REVISION APPD. DATE
 CLIENT
الجمهورية اللبنانية
مجلس الإنماء والإعمار



CONSULTANT
Khatib & Alami
 consolidated engineering company S.A.L.
 PROJECT TITLE
CHHIM GOVERNMENTAL OFFICES BUILDING

DRAWING TITLE
**SECOND FLOOR PLAN
 WATER SUPPLY /
 FIRE FIGHTING LAYOUT**

DESIGNED	NAME	DRAWING NO.
DESIGNED	R.H.	WS104
DRAWN	A.H.	
CHECKED	Y.K.	PROJECT NO.
APPROVED	Y.K.	BY151600
SCALE	1/100	FILE NAME
DATE	February 2016	BY1516-MS-F02
APPROVED FOR CONSTRUCTION		SHEET NO.

TENDER SUBMISSION