


BLOCK - A

NOTES

1- FOR LIST OF DRAWINGS, LEGEND AND GENERAL NOTES REFER TO DWG. E001

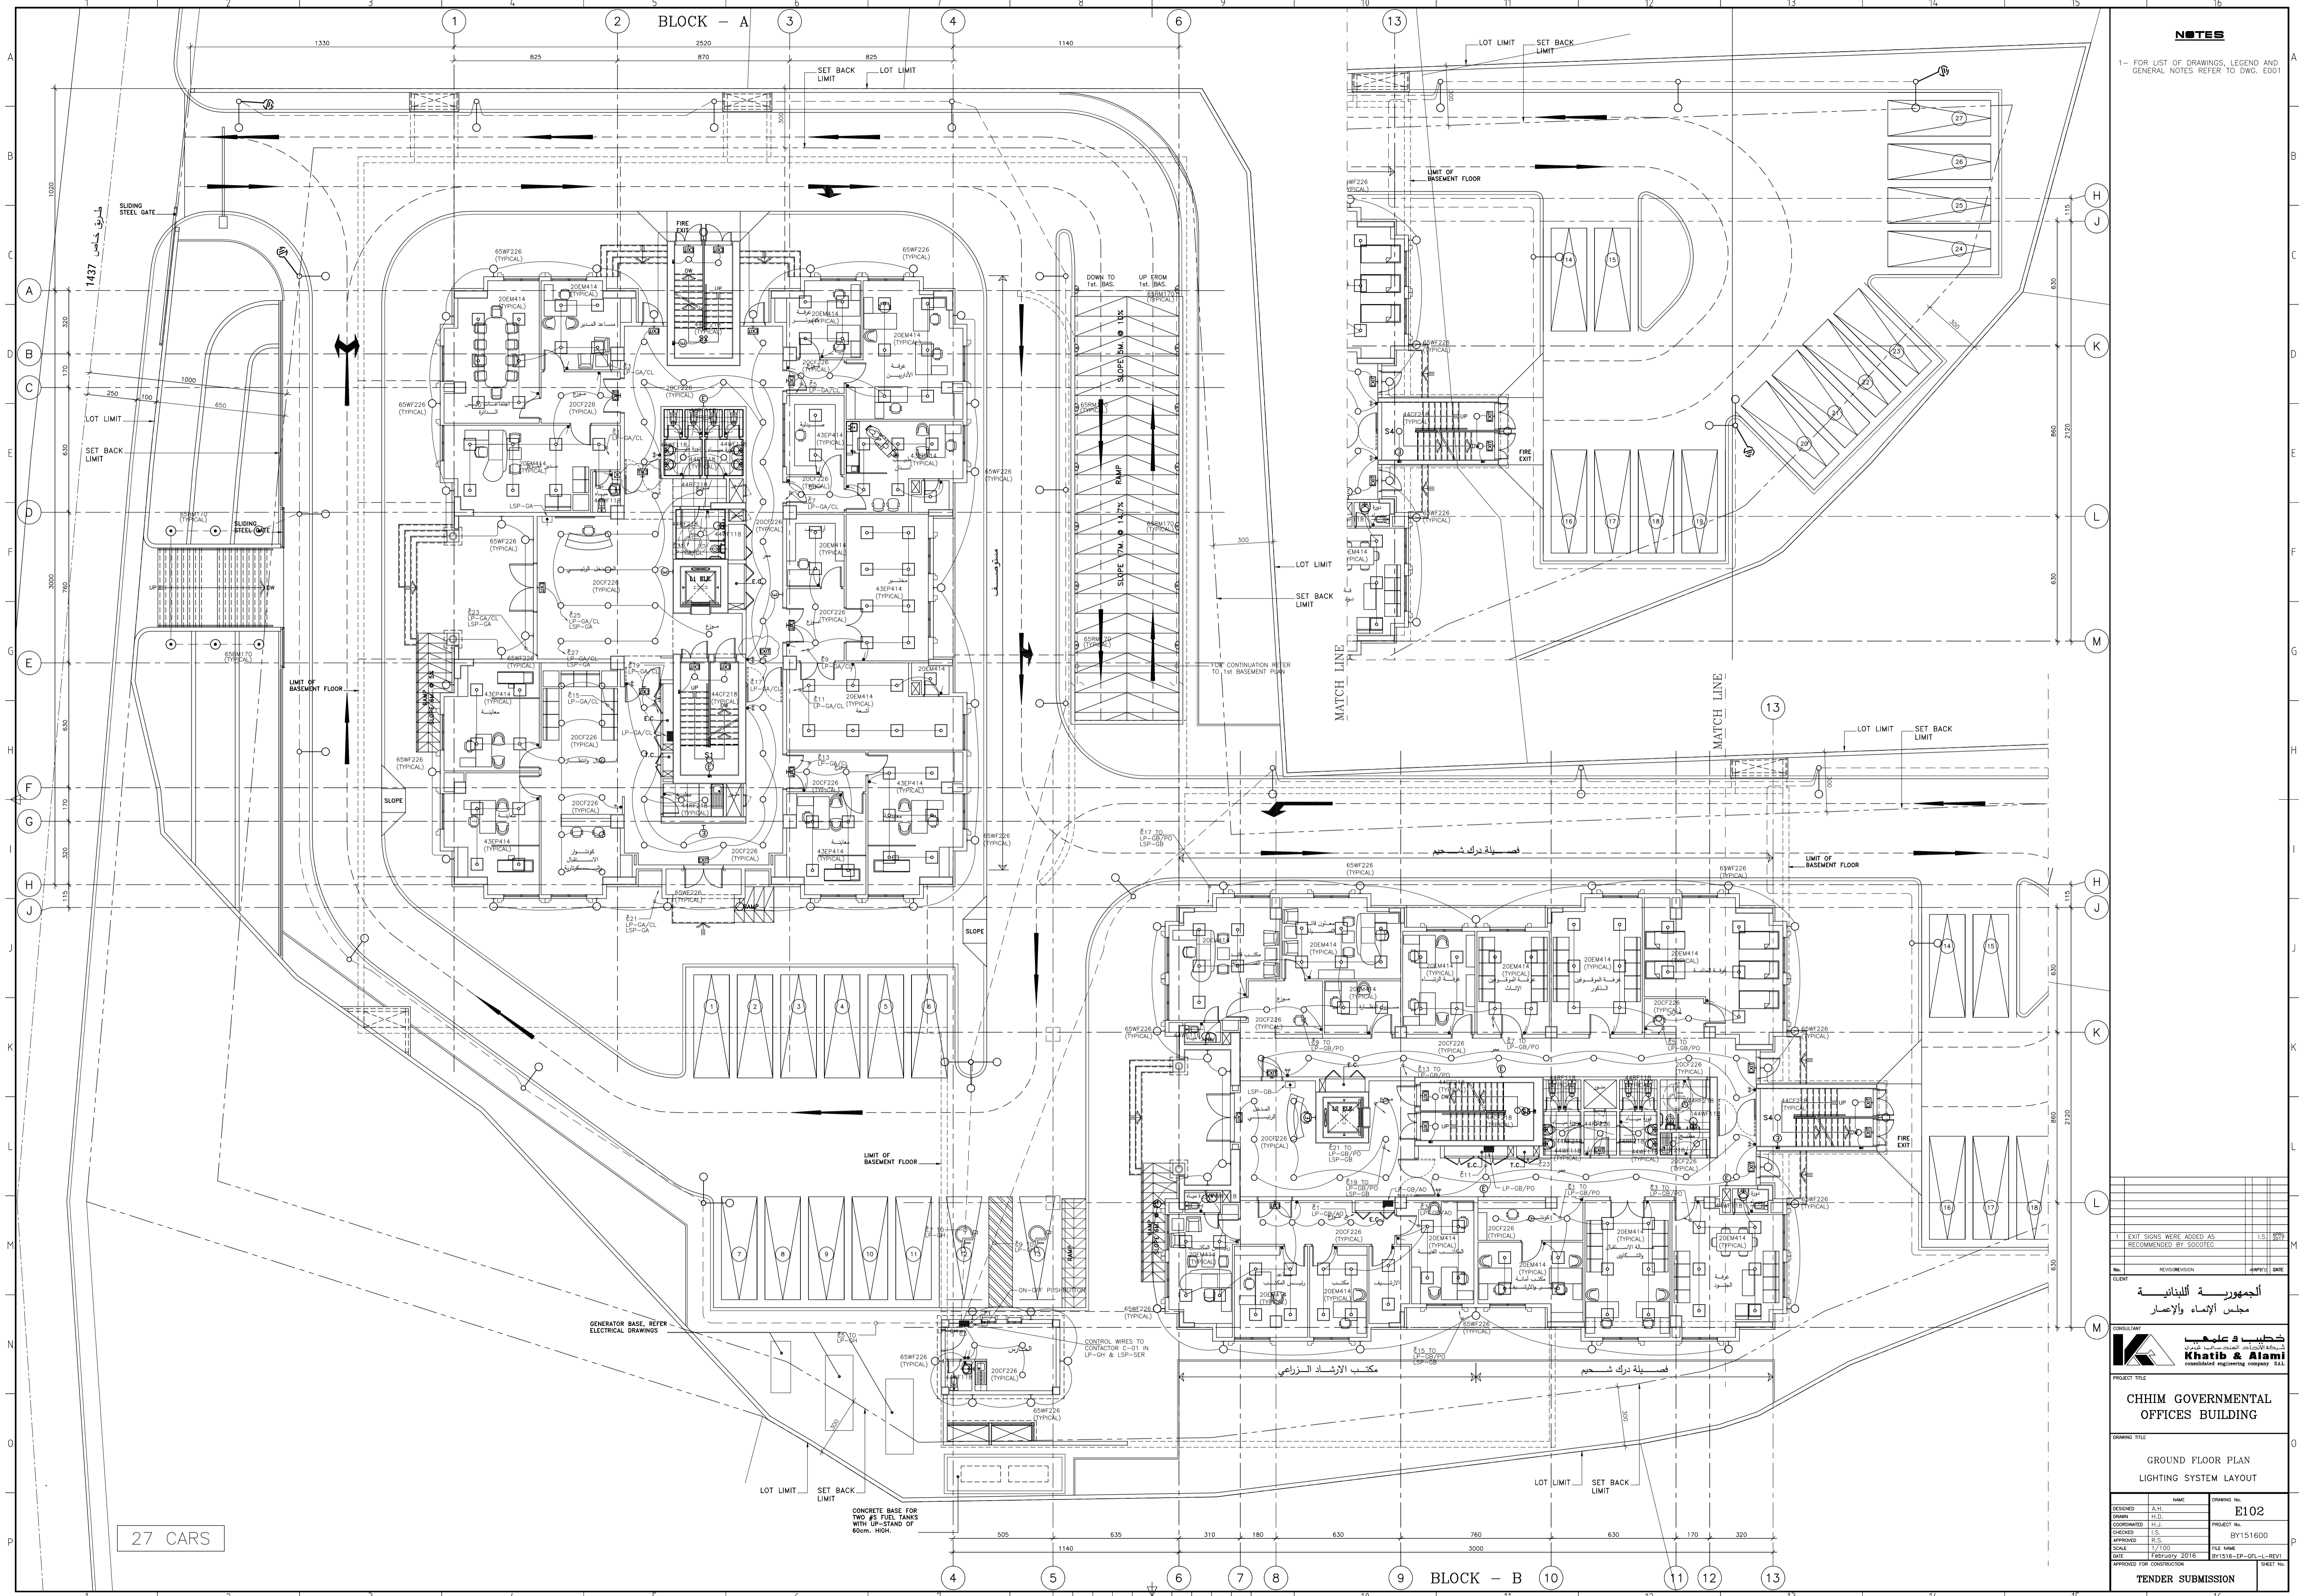

27 CARS

BLOCK - B

1 EXIT SIGNS WERE ADDED AS RECOMMENDED BY SOCOTEC

الجمهورية اللبنانية  
مجلس الإنماء والإعمار

Khatib & Alami  
CONSULTANT

CHHM GOVERNMENTAL OFFICES BUILDING

GROUND FLOOR PLAN  
LIGHTING SYSTEM LAYOUT

DESIGNED	A.H.	DATE	17/1/2016
DRAWN	H.D.	PROJECT NO.	E102
CHECKED	R.S.	PROJECT FILE	BY151600
APPROVED	R.S.	FILE NAME	BY1516-FP-01-REV1
SCALE	1/100	DATE	FEBRUARY 2016
DATE	FEBRUARY 2016	APPROVED FOR CONSTRUCTION	
TENDER SUBMISSION			SHEET NO.