


BLOCK - A

NOTES

1- FOR LIST OF DRAWINGS, LEGEND AND GENERAL NOTES REFER TO DWG. E001

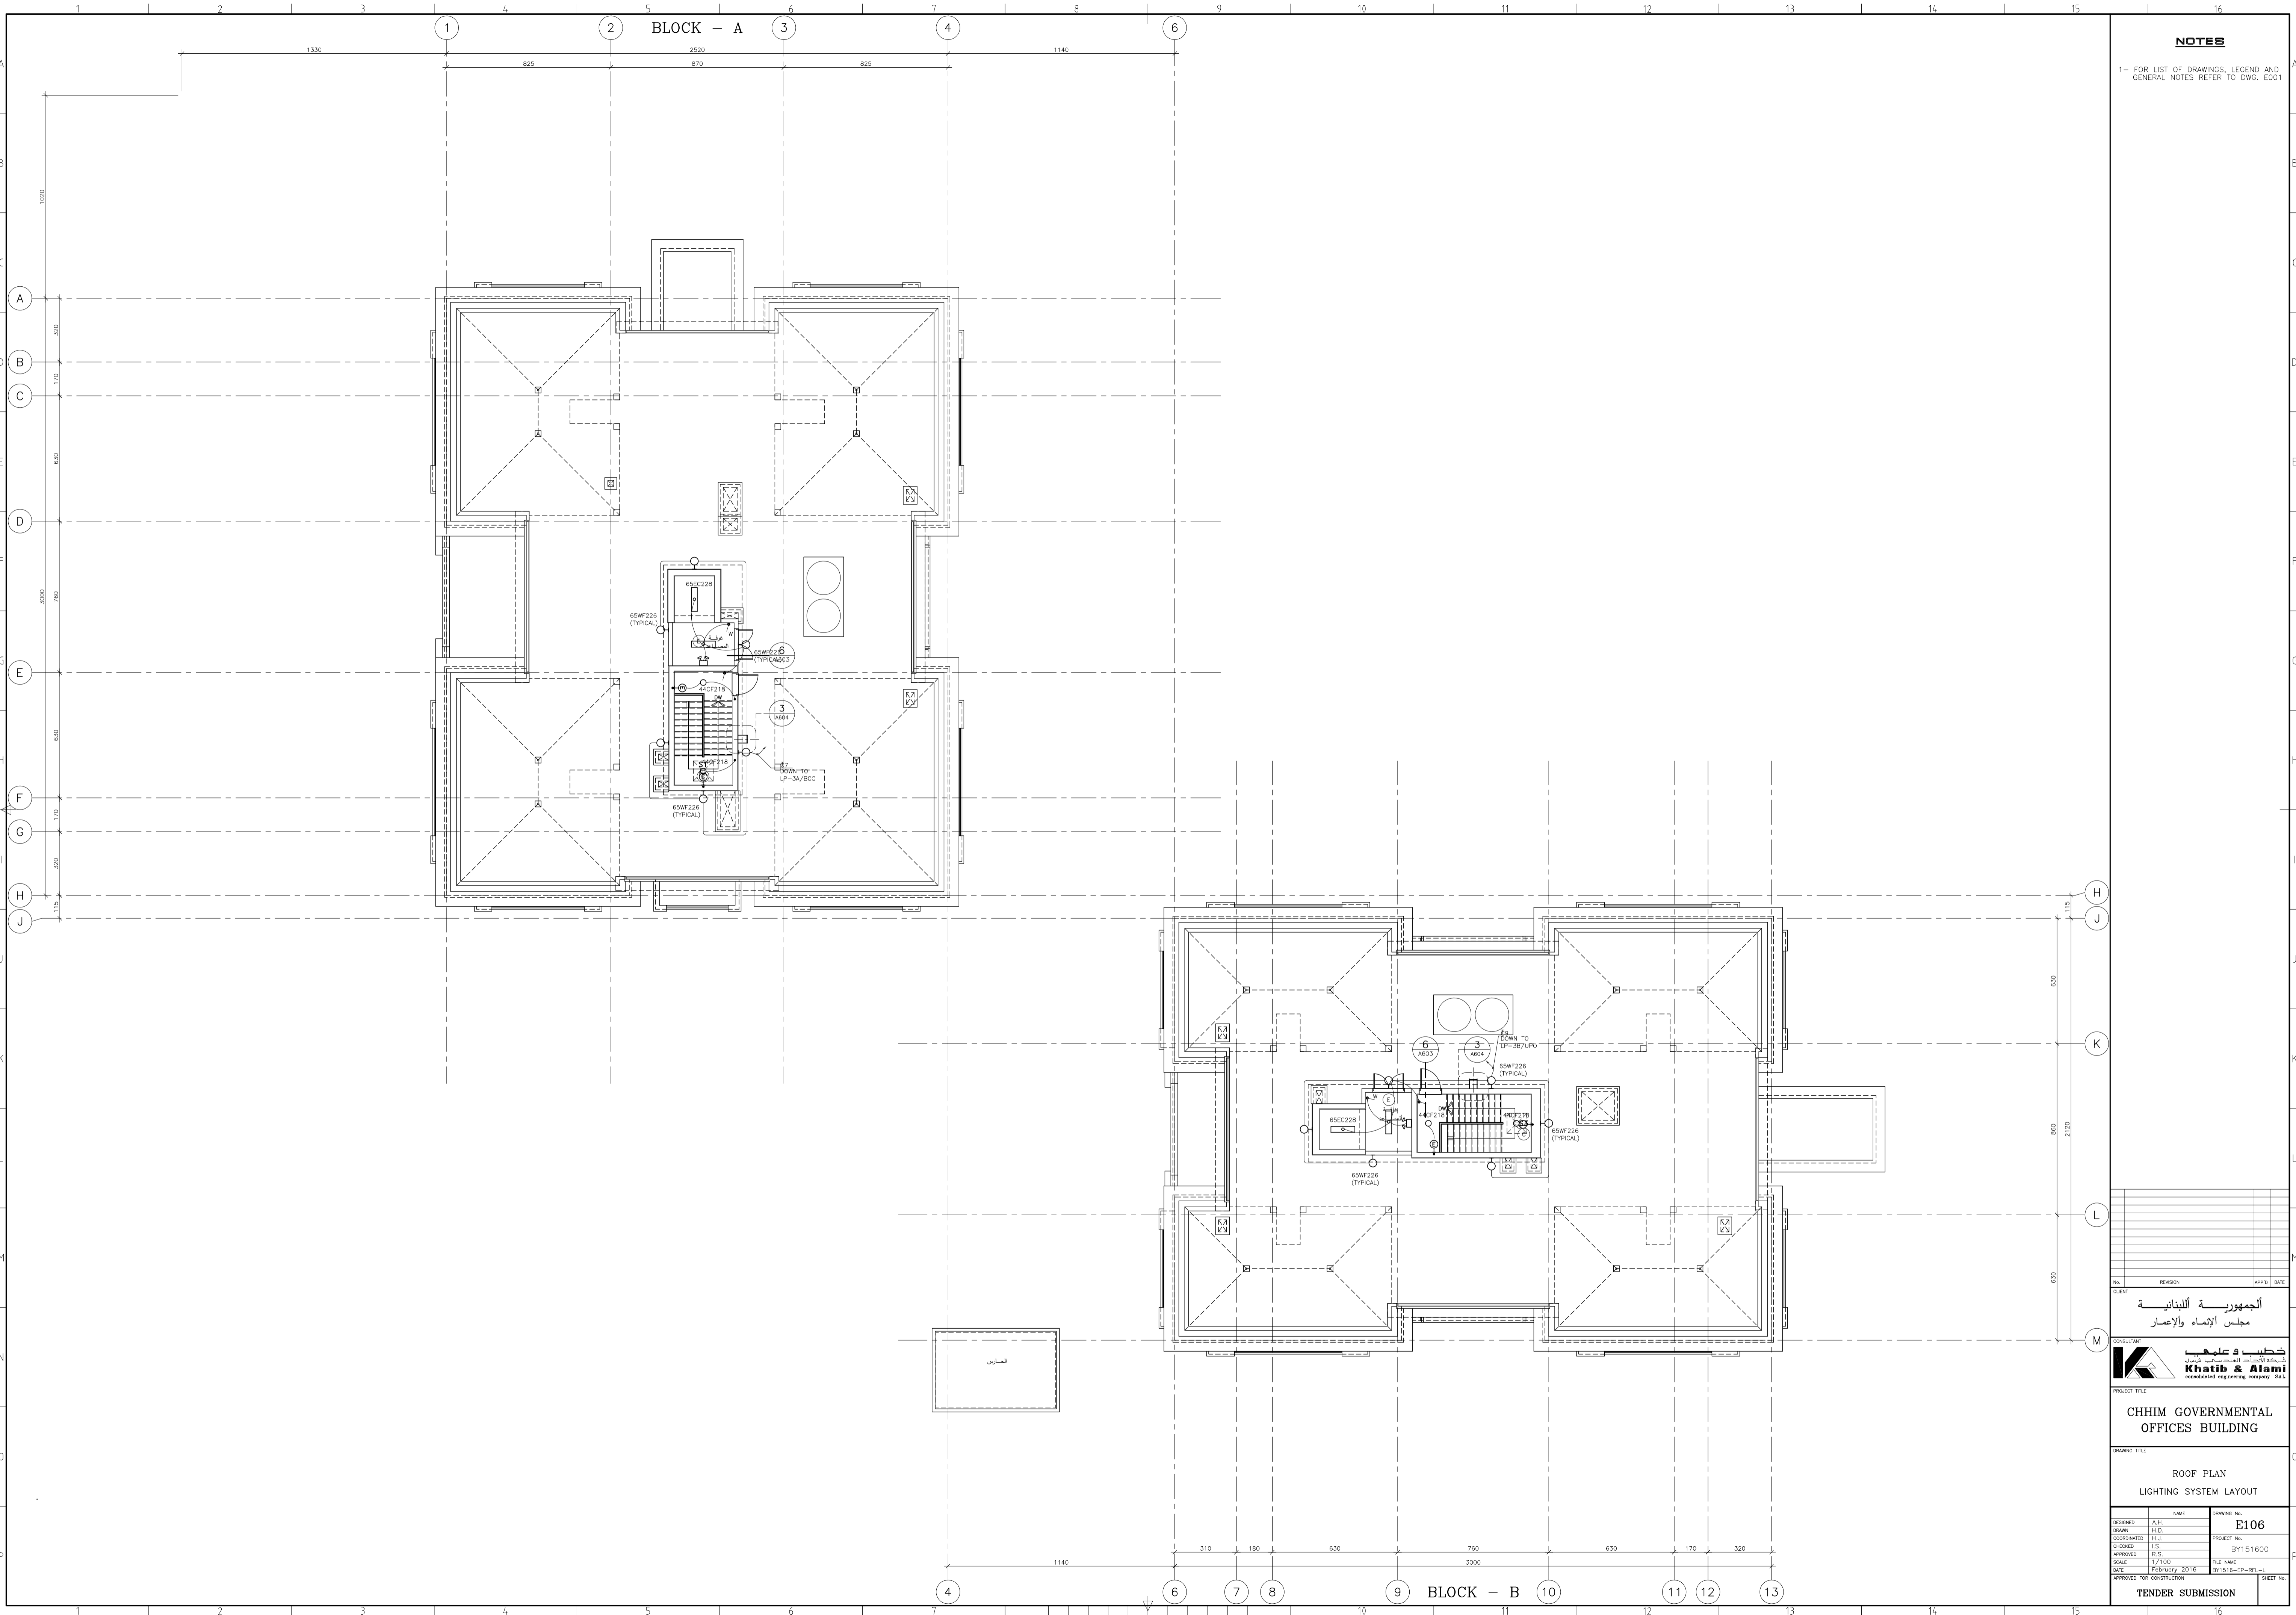

الجمهورية اللبنانية
مجلس الإنماء والإعمار



CHHIM GOVERNMENTAL
OFFICES BUILDING

ROOF PLAN
LIGHTING SYSTEM LAYOUT

DESIGNED	NAME	DRAWING NO.
DESIGNED	A.H.	E106
DRAWN	H.L.	
CHECKED	R.S.	PROJECT NO. BY151600
APPROVED	R.S.	FILE NAME
SCALE	1/100	DATE
DATE	February 2016	BY1516-EP-001-L

TENDER SUBMISSION