


BLOCK - A

NOTES

1- FOR LIST OF DRAWINGS, LEGEND AND GENERAL NOTES REFER TO DWG. E001

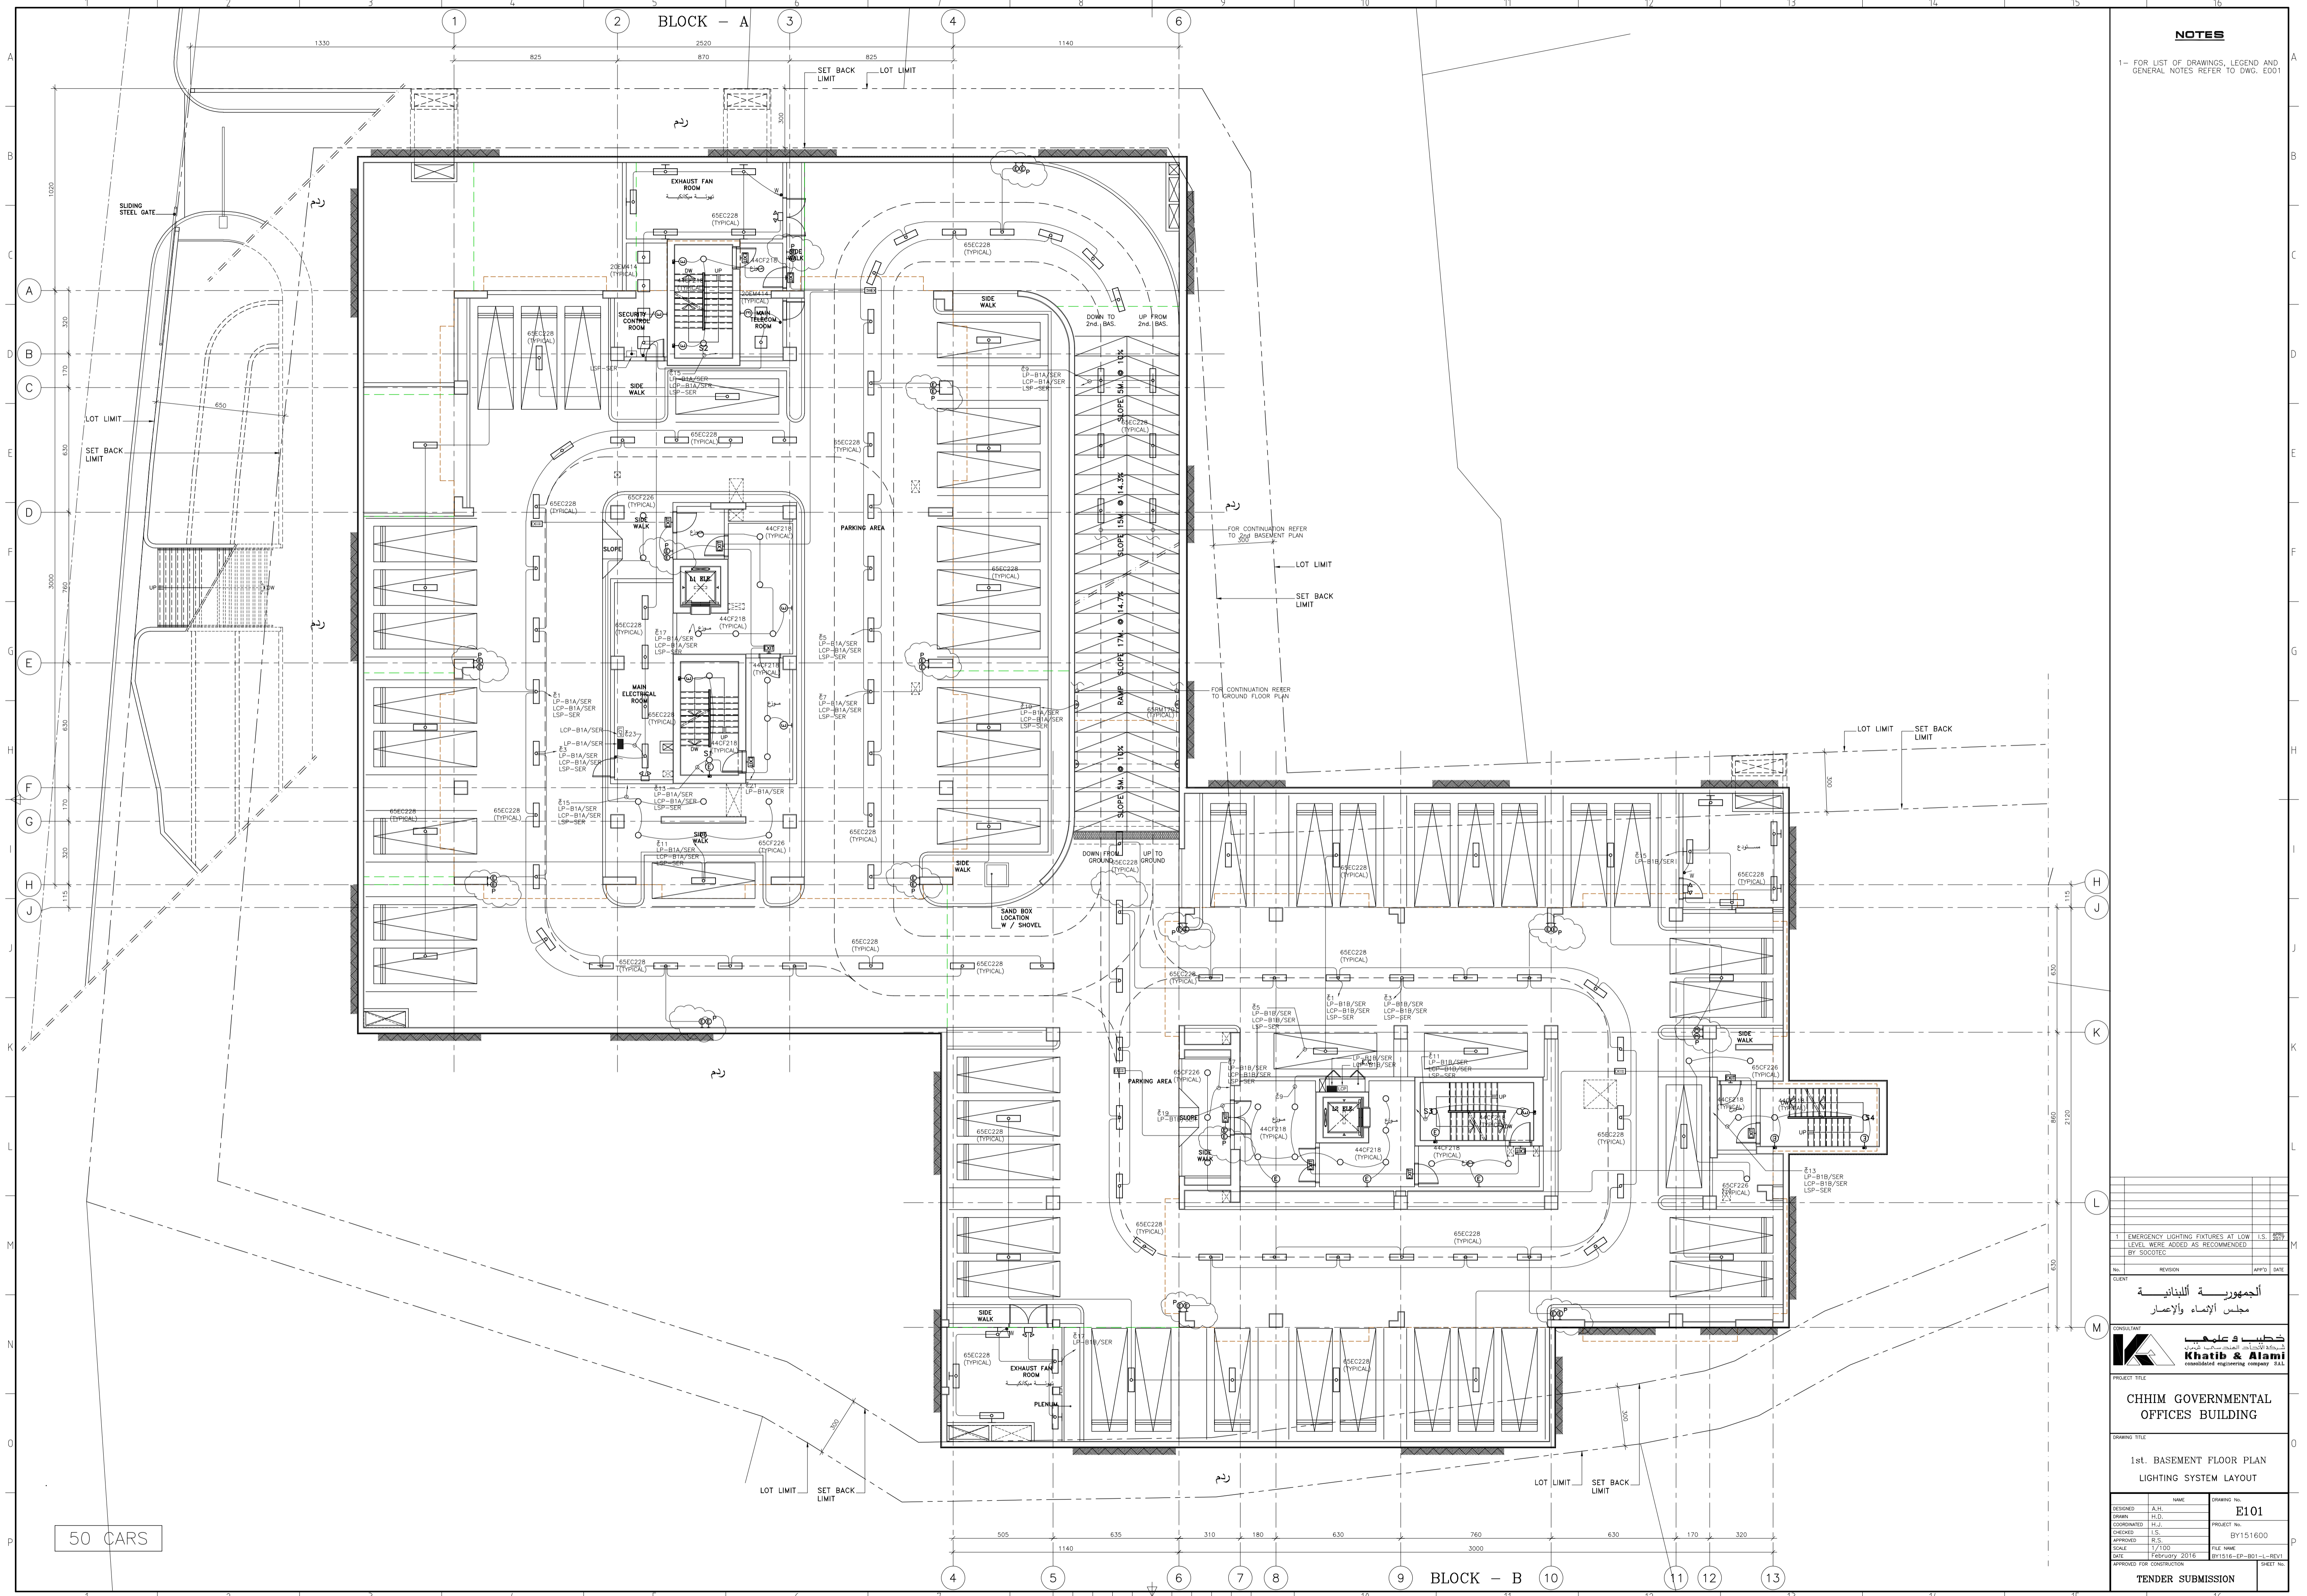

50 CARS

1 EMERGENCY LIGHTING FIXTURES AT LOW LEVEL (S.S. 201)			
LEVEL MARKS ADDED AS RECOMMENDED BY SOCIETY			
NO.	REVISION	APP'D	DATE
العميل: الجمهورية اللبنانية مجلس الإنماء والإعمار			
الاستشاري: خطيب وعلامة Khatib & Alami consolidated engineering company S.A.L.			

PROJECT TITLE		DRAWING NO.	
CHHM GOVERNMENTAL OFFICES BUILDING		E101	
DRAWING TITLE		PROJECT NO.	
1st. BASEMENT FLOOR PLAN		BY151600	
LIGHTING SYSTEM LAYOUT		FILE NAME	
DESIGNED: A.H.		SCALE	
DRAWN: H.D.		1/100	
COORDINATED: H.S.		DATE	
CHECKED: R.S.		February 2016	
APPROVED FOR CONSTRUCTION		BY1516-EP-001-REV1	
TENDER SUBMISSION		SHEET NO.	