



NOTES

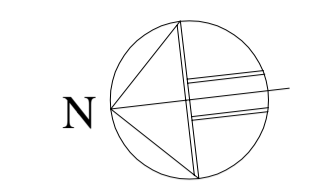

- 1-FOR LEGEND, GENERAL NOTES AND LIST OF MECHANICAL DRAWINGS REFER TO DRAWING No. BY1516-GNL-00.
- 2-FOR RISER DIAGRAM REFER TO DRAWING BY1516-GNL-02.
- 3-FOR MISCELLANEOUS DETAILS, REFER TO DRAWING No. BY1516-GNL-01.
- 4-FLUE PIPE DIAMETER SHOULD BE VERIFIED BY THE BOILERS SUPPLIER.

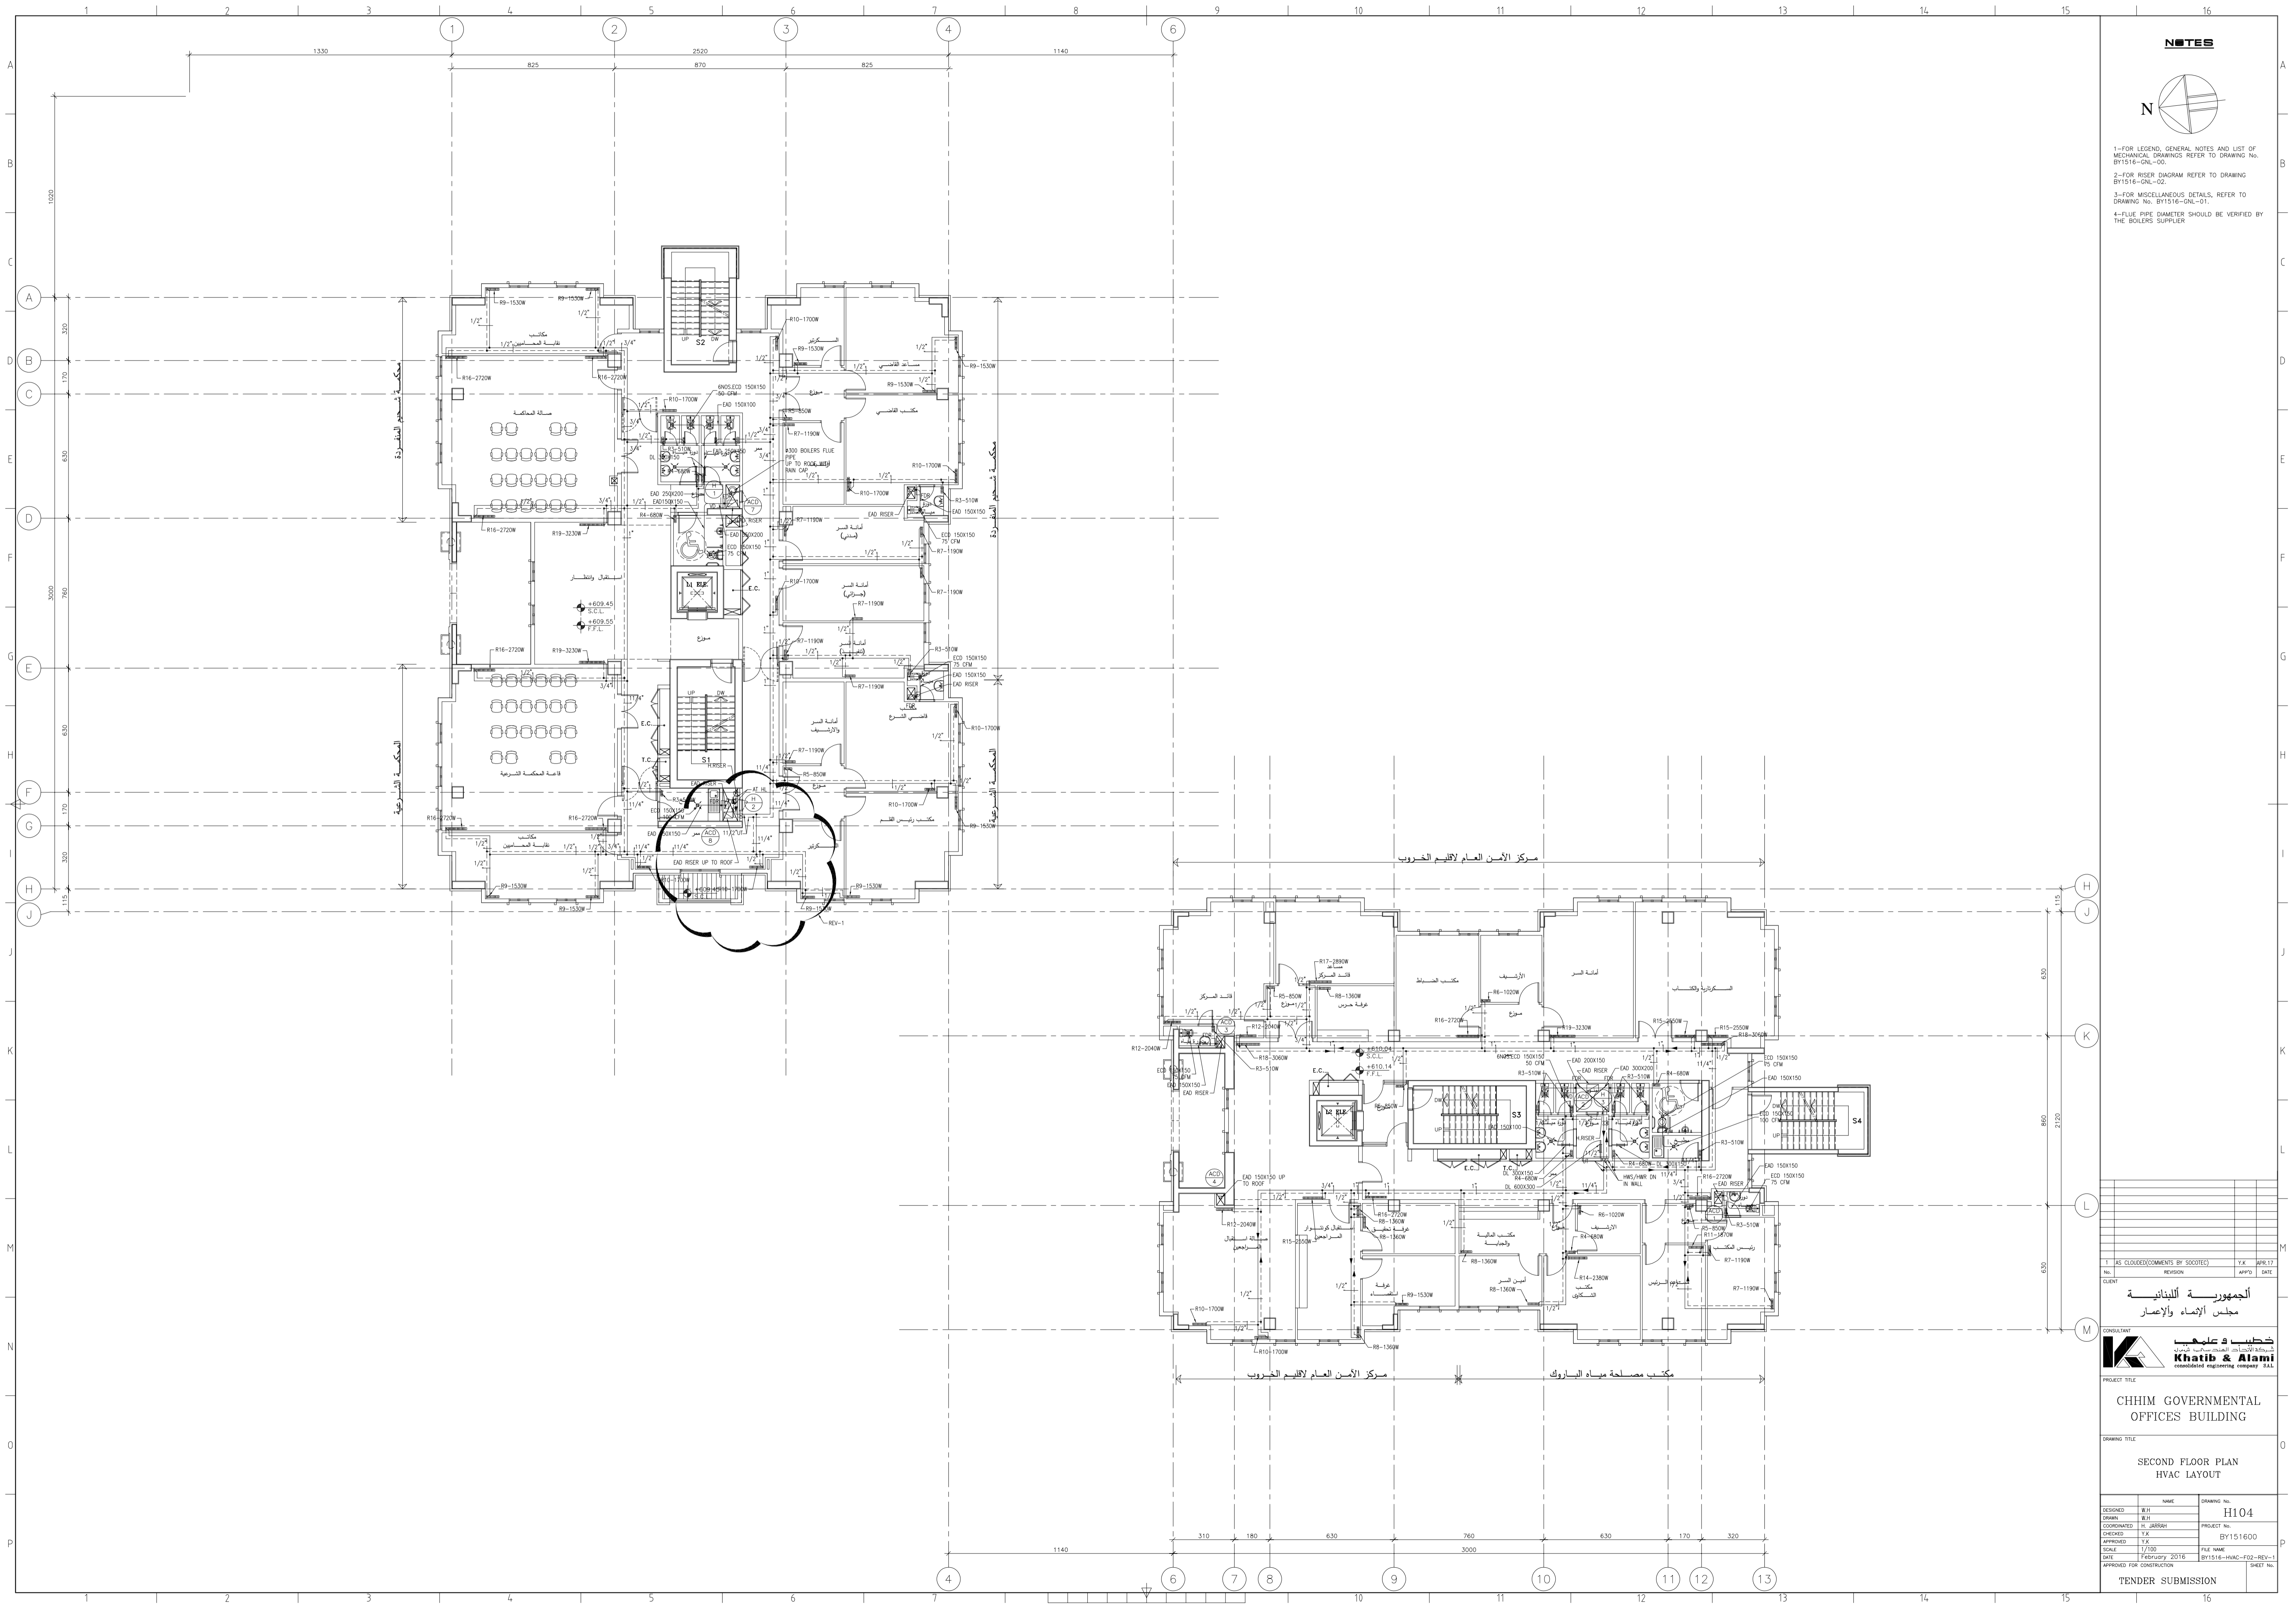

<p>1 AS CLOUDED (COMMENTS BY S0010C) T.X. APR.17</p> <p>No. REGION APP'D DATE</p> <p>CLIENT</p> <p style="text-align: center;">الجمهورية اللبنانية مجلس الإنماء والإعمار</p> <p>CONSULTANT</p> <p style="text-align: center;">خطيب وعلامة Khatib & Alami consolidated engineering company S.A.L.</p> <p>PROJECT TITLE</p> <p style="text-align: center;">CHHM GOVERNMENTAL OFFICES BUILDING</p> <p>DRAWING TITLE</p> <p style="text-align: center;">SECOND FLOOR PLAN HVAC LAYOUT</p> <table border="1" style="width: 100%; border-collapse: collapse;"> <thead> <tr> <th>DESIGNED</th> <th>BY</th> <th>NAME</th> <th>DRAWING NO.</th> </tr> </thead> <tbody> <tr> <td>DESIGNED</td> <td>E.H.</td> <td></td> <td>H104</td> </tr> <tr> <td>COORDINATED</td> <td>M. GHORRI</td> <td></td> <td>PROJECT No. BY151600</td> </tr> <tr> <td>CHECKED</td> <td>T.X.</td> <td></td> <td>FILE NAME</td> </tr> <tr> <td>APPROVED</td> <td>T.X.</td> <td></td> <td>DATE</td> </tr> <tr> <td>SCALE</td> <td>1/100</td> <td></td> <td>BY1516-HVAC-F02-REV-1</td> </tr> <tr> <td>DATE</td> <td>February 2016</td> <td></td> <td>SHEET No.</td> </tr> <tr> <td>APPROVED FOR CONSTRUCTION</td> <td></td> <td></td> <td></td> </tr> </tbody> </table> <p style="text-align: center;">TENDER SUBMISSION</p>	DESIGNED	BY	NAME	DRAWING NO.	DESIGNED	E.H.		H104	COORDINATED	M. GHORRI		PROJECT No. BY151600	CHECKED	T.X.		FILE NAME	APPROVED	T.X.		DATE	SCALE	1/100		BY1516-HVAC-F02-REV-1	DATE	February 2016		SHEET No.	APPROVED FOR CONSTRUCTION				
DESIGNED	BY	NAME	DRAWING NO.																														
DESIGNED	E.H.		H104																														
COORDINATED	M. GHORRI		PROJECT No. BY151600																														
CHECKED	T.X.		FILE NAME																														
APPROVED	T.X.		DATE																														
SCALE	1/100		BY1516-HVAC-F02-REV-1																														
DATE	February 2016		SHEET No.																														
APPROVED FOR CONSTRUCTION																																	