


BLOCK - A

NOTES

1- FOR LIST OF DRAWINGS, LEGEND AND GENERAL NOTES REFER TO DWG. E001

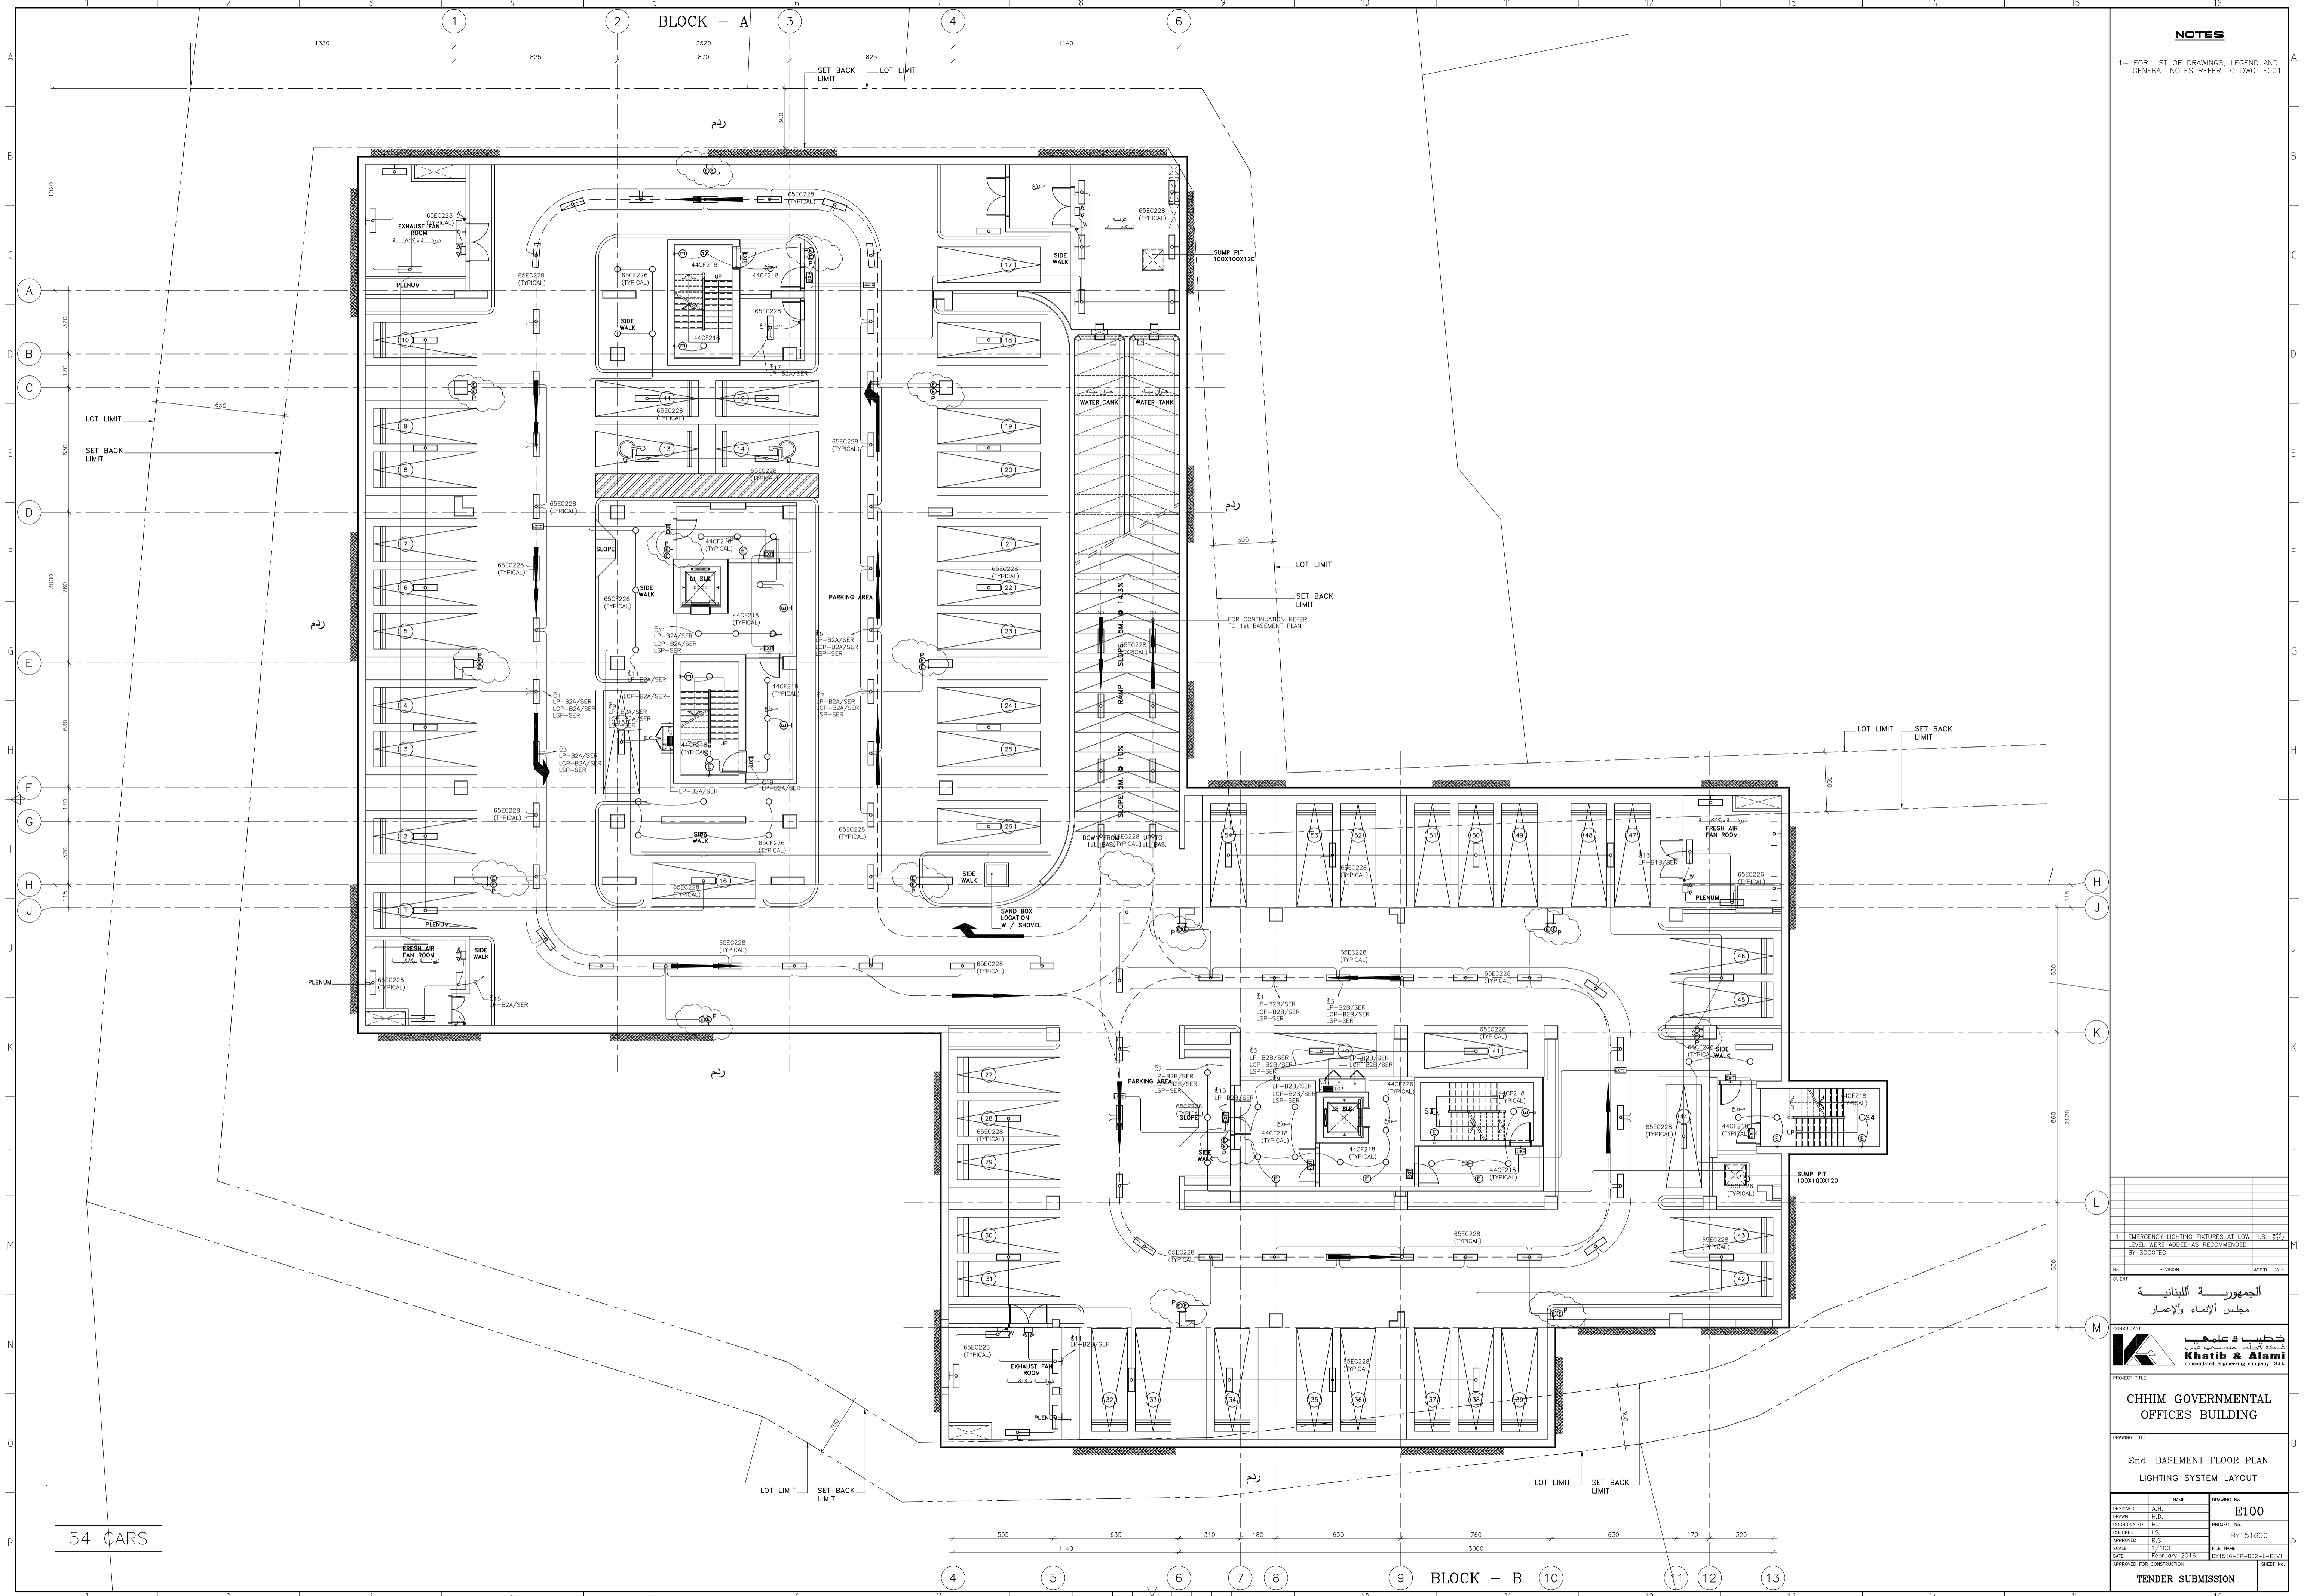

54 CARS

1 EMERGENCY LIGHTING FIXTURES AT LOW LEVEL (S. 201)			
LEVEL MARKS ADDED AS RECOMMENDED BY SOCIETIES			
NO.	REVISION	APP'D	DATE
الجمهورية اللبنانية مجلس الإنماء والإعمار			
كاتب وعلما Khatib & Alami consolidated engineering company S.A.L.			
PROJECT TITLE			
CHHIM GOVERNMENTAL OFFICES BUILDING			
DRAWING TITLE			
2nd. BASEMENT FLOOR PLAN			
LIGHTING SYSTEM LAYOUT			
DESIGNED	A.H.	DATE	E100
DRAWN	H.D.	PROJECT NO.	BY151600
COORDINATED	H.L.	FILE NAME	BY1516-EP-802-REV1
CHECKED	R.S.	DATE	February 2016
APPROVED	R.S.	DATE	February 2016
SCALE	1/100	DATE	February 2016
DATE	February 2016	DATE	February 2016
APPROVED FOR CONSTRUCTION		DATE	February 2016
TENDER SUBMISSION			

BLOCK - B