


**NOTES**

1- FOR LIST OF DRAWINGS, LEGEND AND GENERAL NOTES REFER TO DWG. E001

**BLOCK - A**

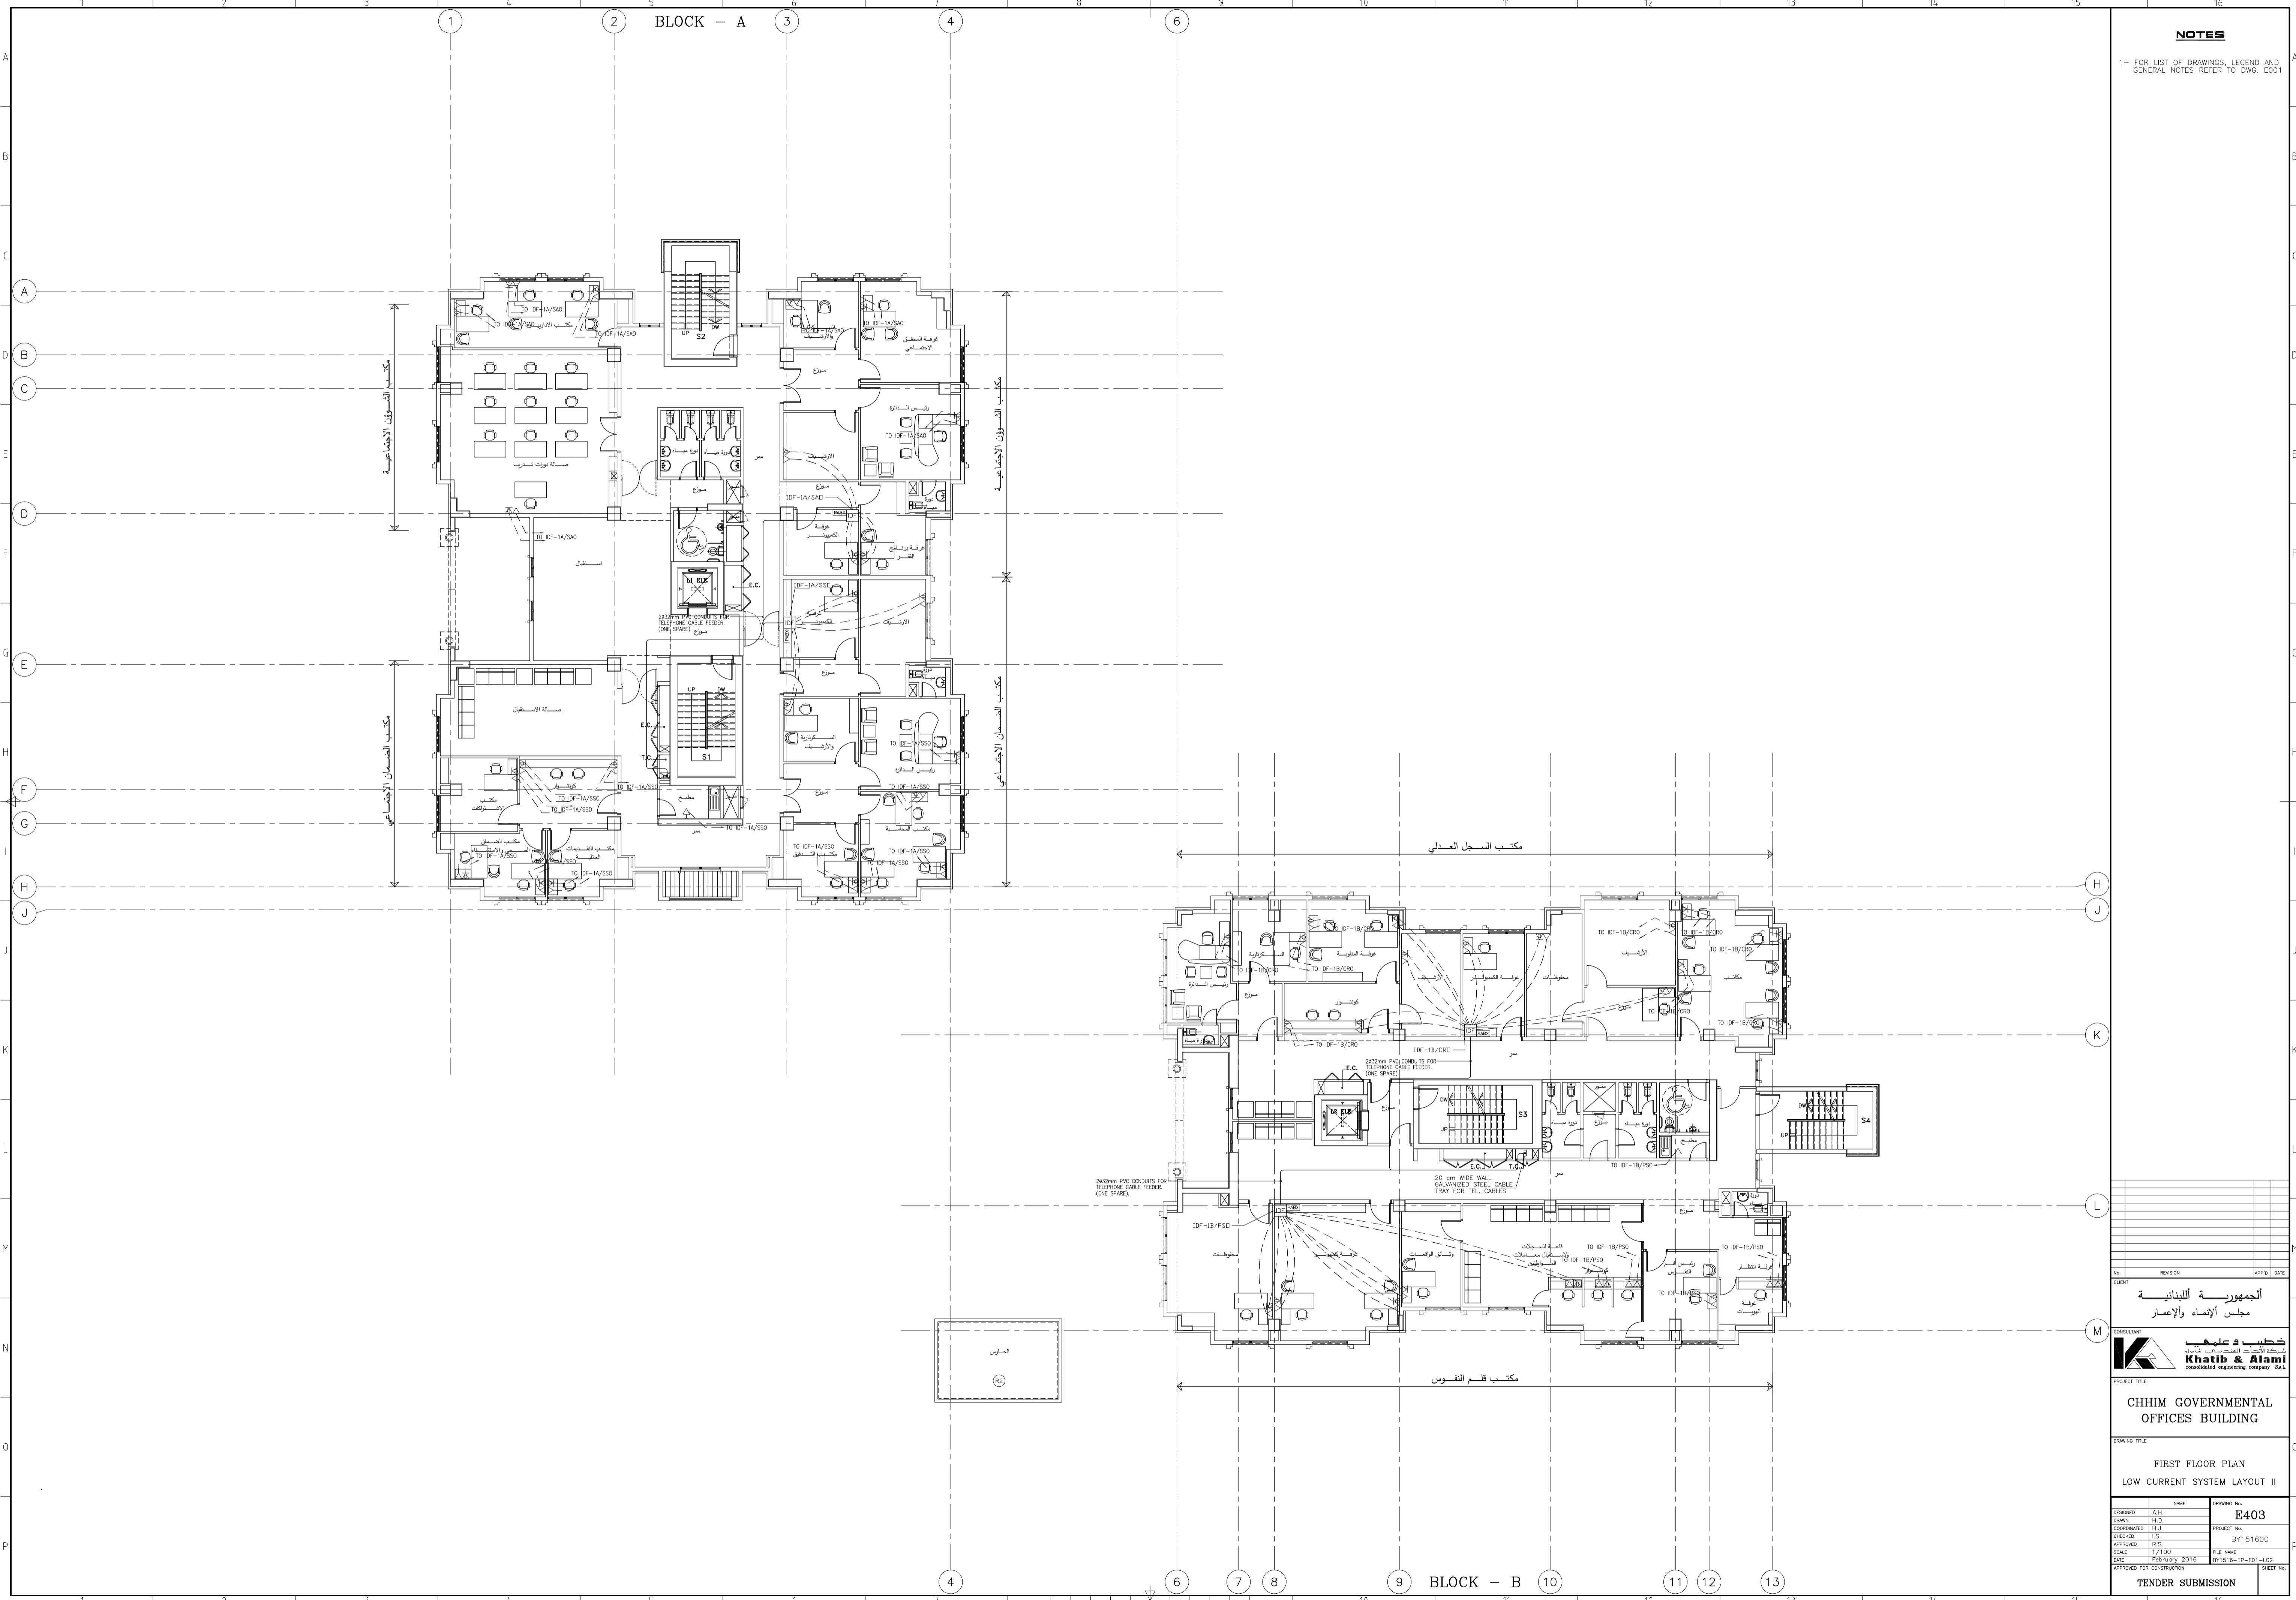

الجمهورية اللبنانية  
مجلس الإنماء والإعمار



**CHHIM GOVERNMENTAL OFFICES BUILDING**

**FIRST FLOOR PLAN  
LOW CURRENT SYSTEM LAYOUT II**

DESIGNED	NAME	DRAWING NO.
DESIGNED	A.H.	E403
DRAWN	H.L.	
COORDINATED	H.L.	PROJECT NO. BY151600
CHECKED	R.S.	FILE NAME
APPROVED	R.S.	DATE
SCALE	1/100	BY1516-FP-F01-L02
DATE	February 2016	SHEET NO.

APPROVED FOR CONSTRUCTION  
**TENDER SUBMISSION**