



NOTES

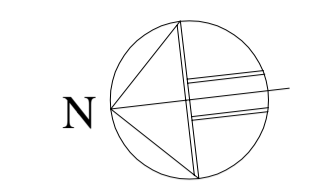

- 1-FOR LEGEND, GENERAL NOTES AND LIST OF MECHANICAL DRAWINGS REFER TO DRAWING No. BY1516-GNL-00.
- 2-FOR RISER DIAGRAM REFER TO DRAWING BY1516-GNL-02.
- 3-FOR MISCELLANEOUS DETAILS, REFER TO DRAWING No. BY1516-GNL-01.
- 4-FLUE PIPE DIAMETER SHOULD BE VERIFIED BY THE BOILERS SUPPLIER.

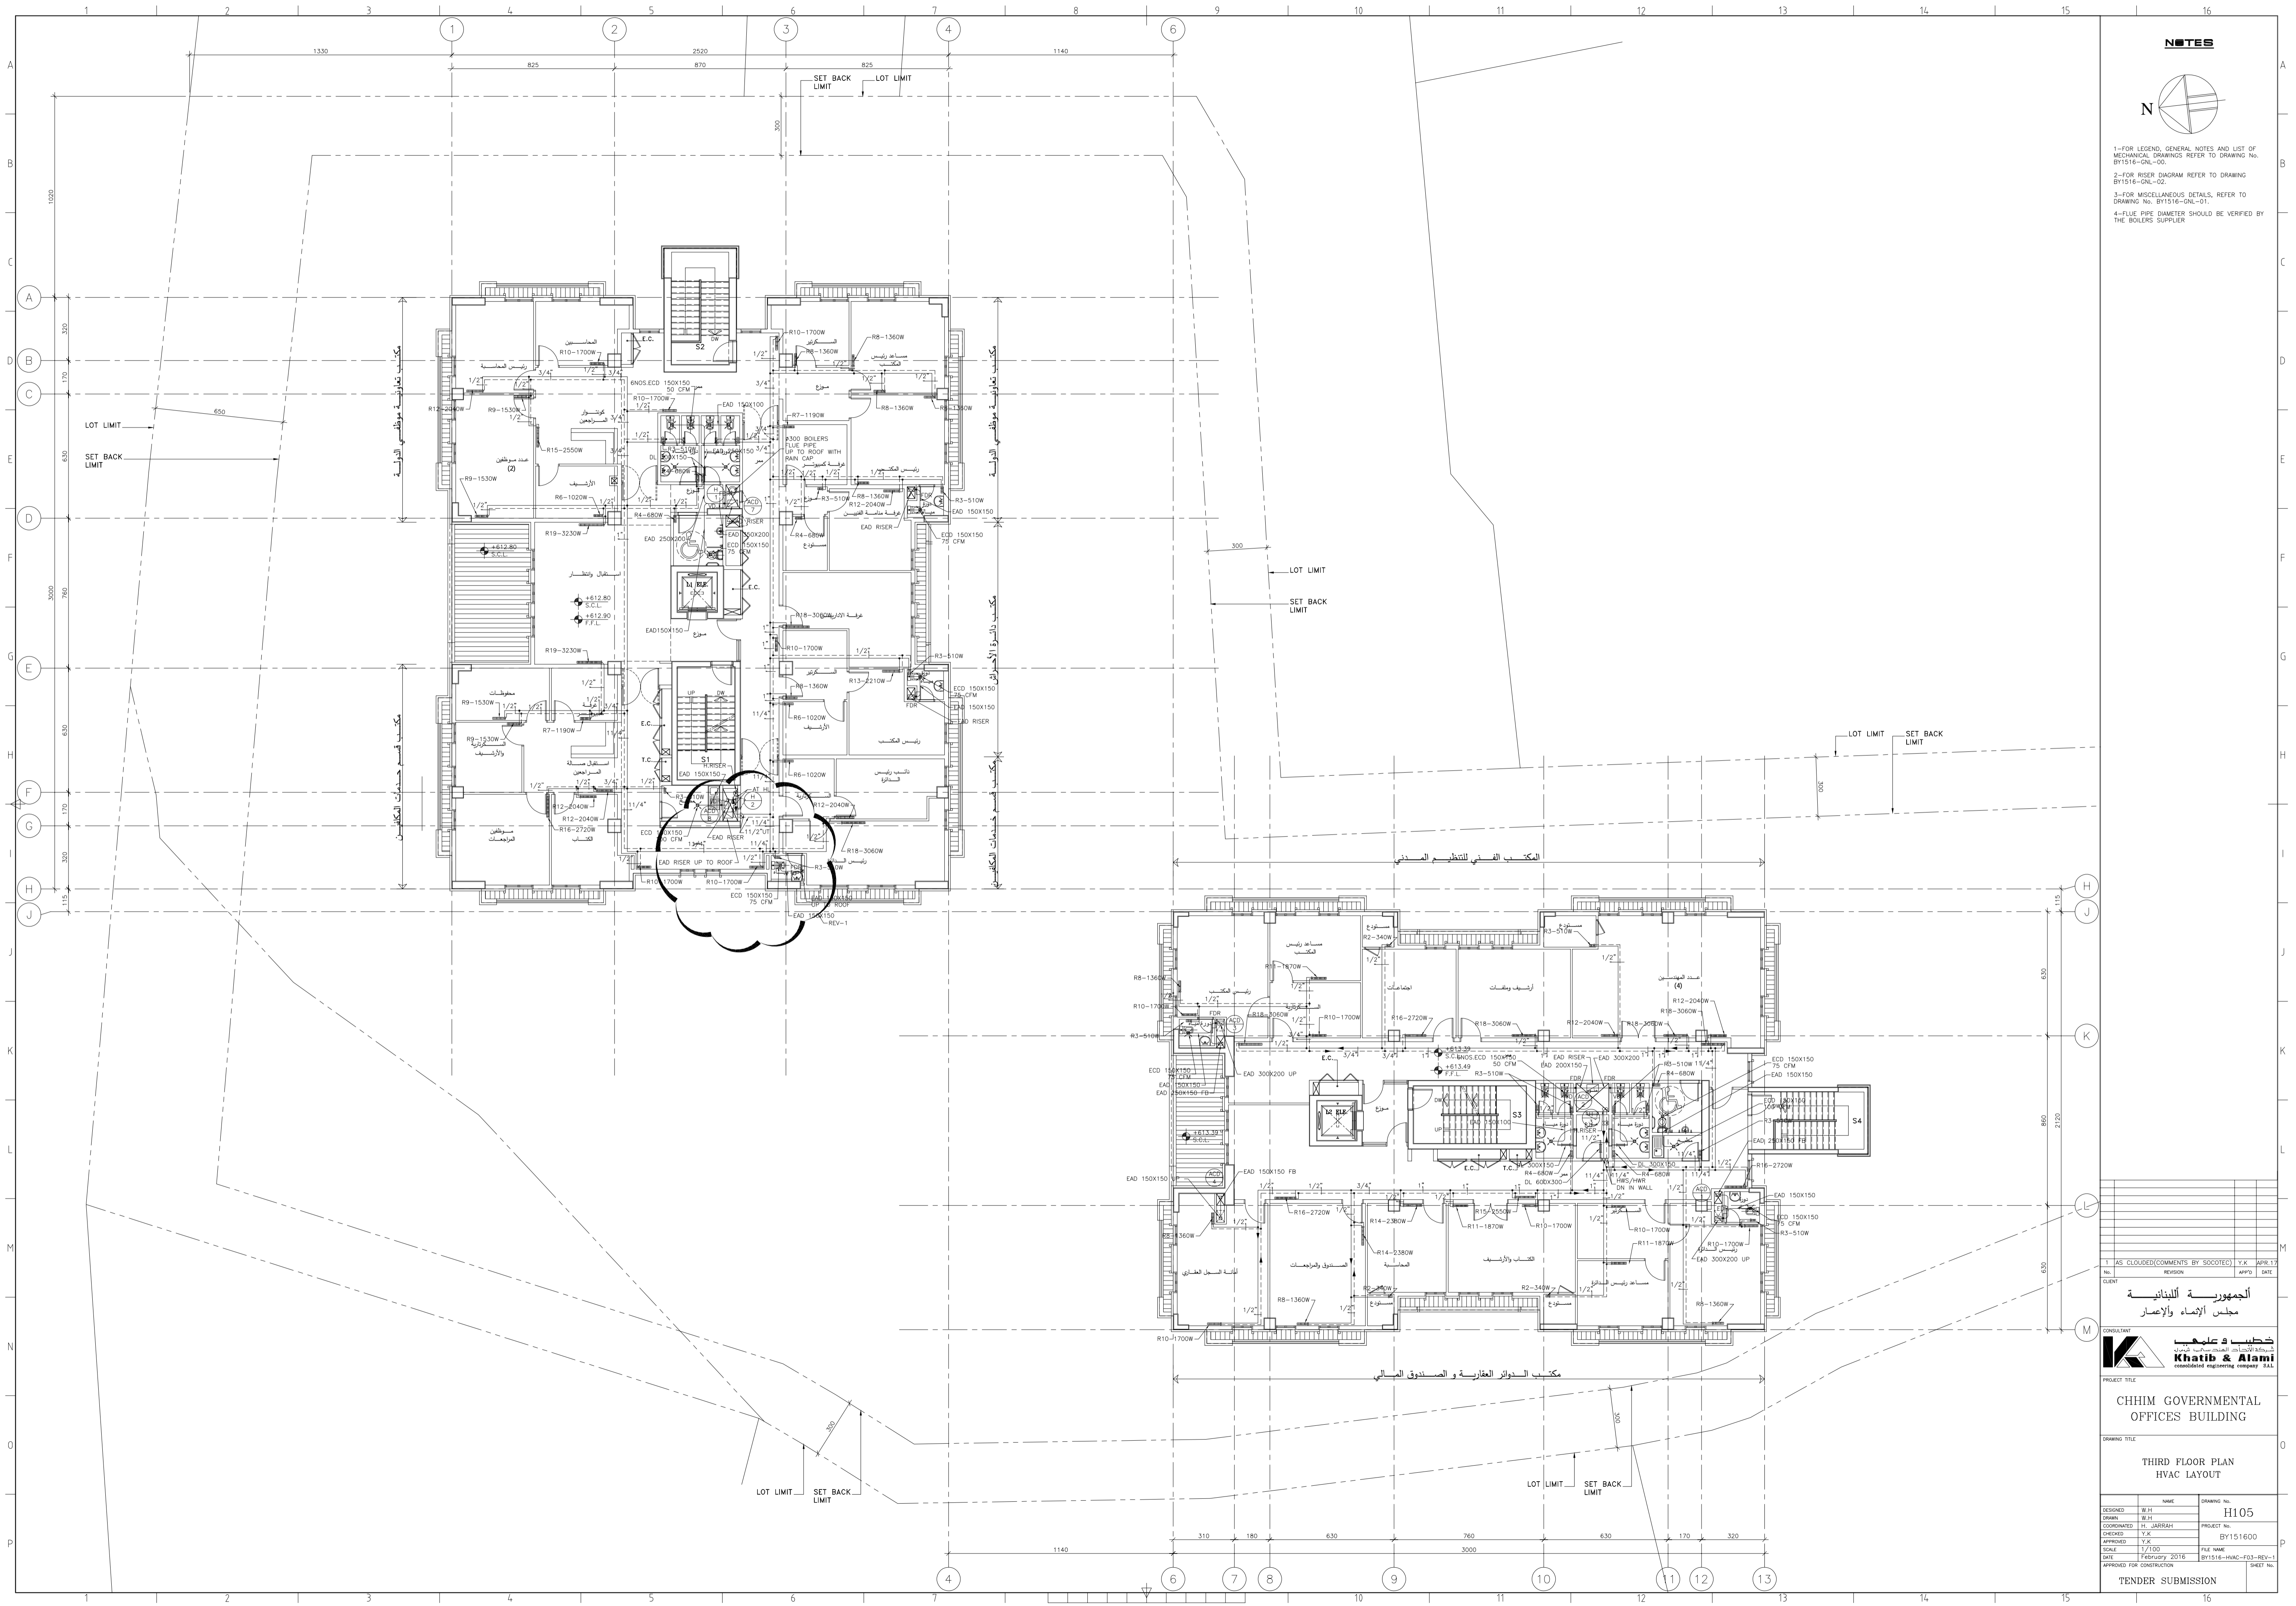

DESIGNED	W.H	DRAWING No.	H105
CHECKED	W.H	PROJECT No.	BY151600
DATE	17/10	FILE NAME	BY1516-HVAC-F03-REV-1
APPROVED	Y.K	DATE	February 2016
SCALE	1/100	APPROVED FOR CONSTRUCTION	
TENDER SUBMISSION			

الجمهورية اللبنانية
مجلس الإنماء والإعمار

خطيب وعلية
Khatib & Alami
consolidated engineering company S.A.L.

CHHIM GOVERNMENTAL OFFICES BUILDING

THIRD FLOOR PLAN
HVAC LAYOUT